



BASEMENT FLOOR PLAN



GROUND FLOOR PLAN

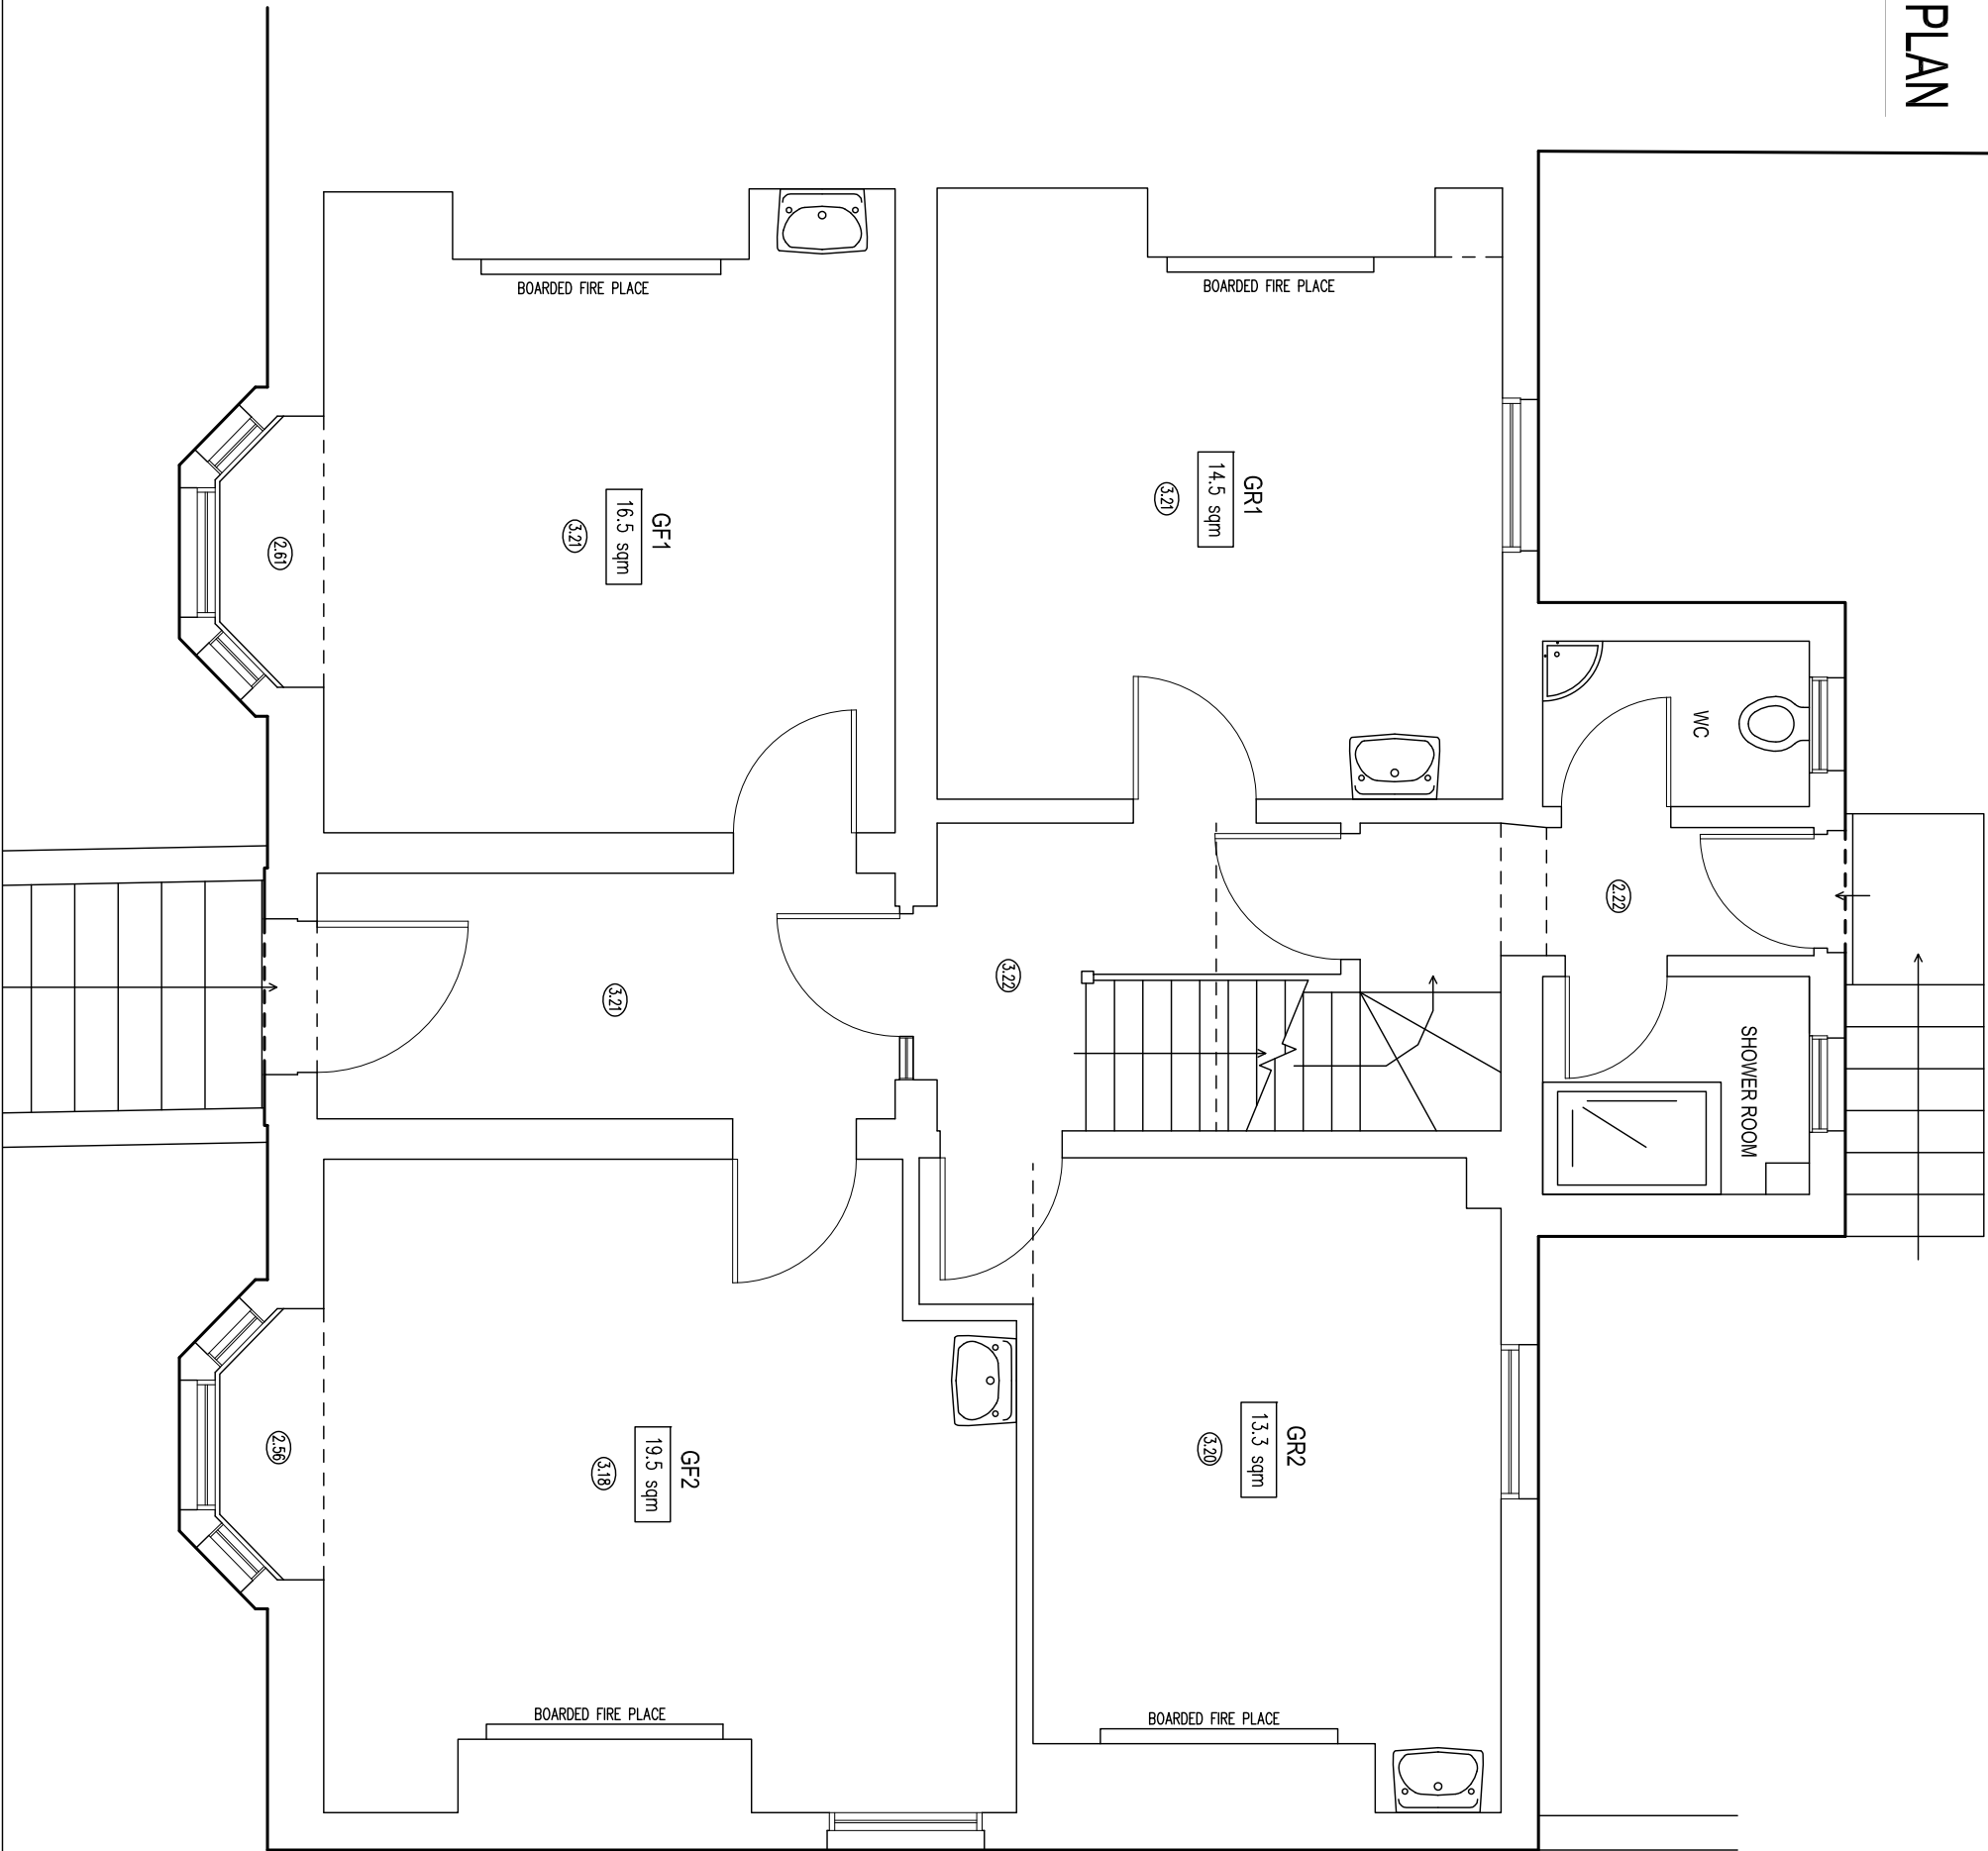

FIRST FLOOR PLAN


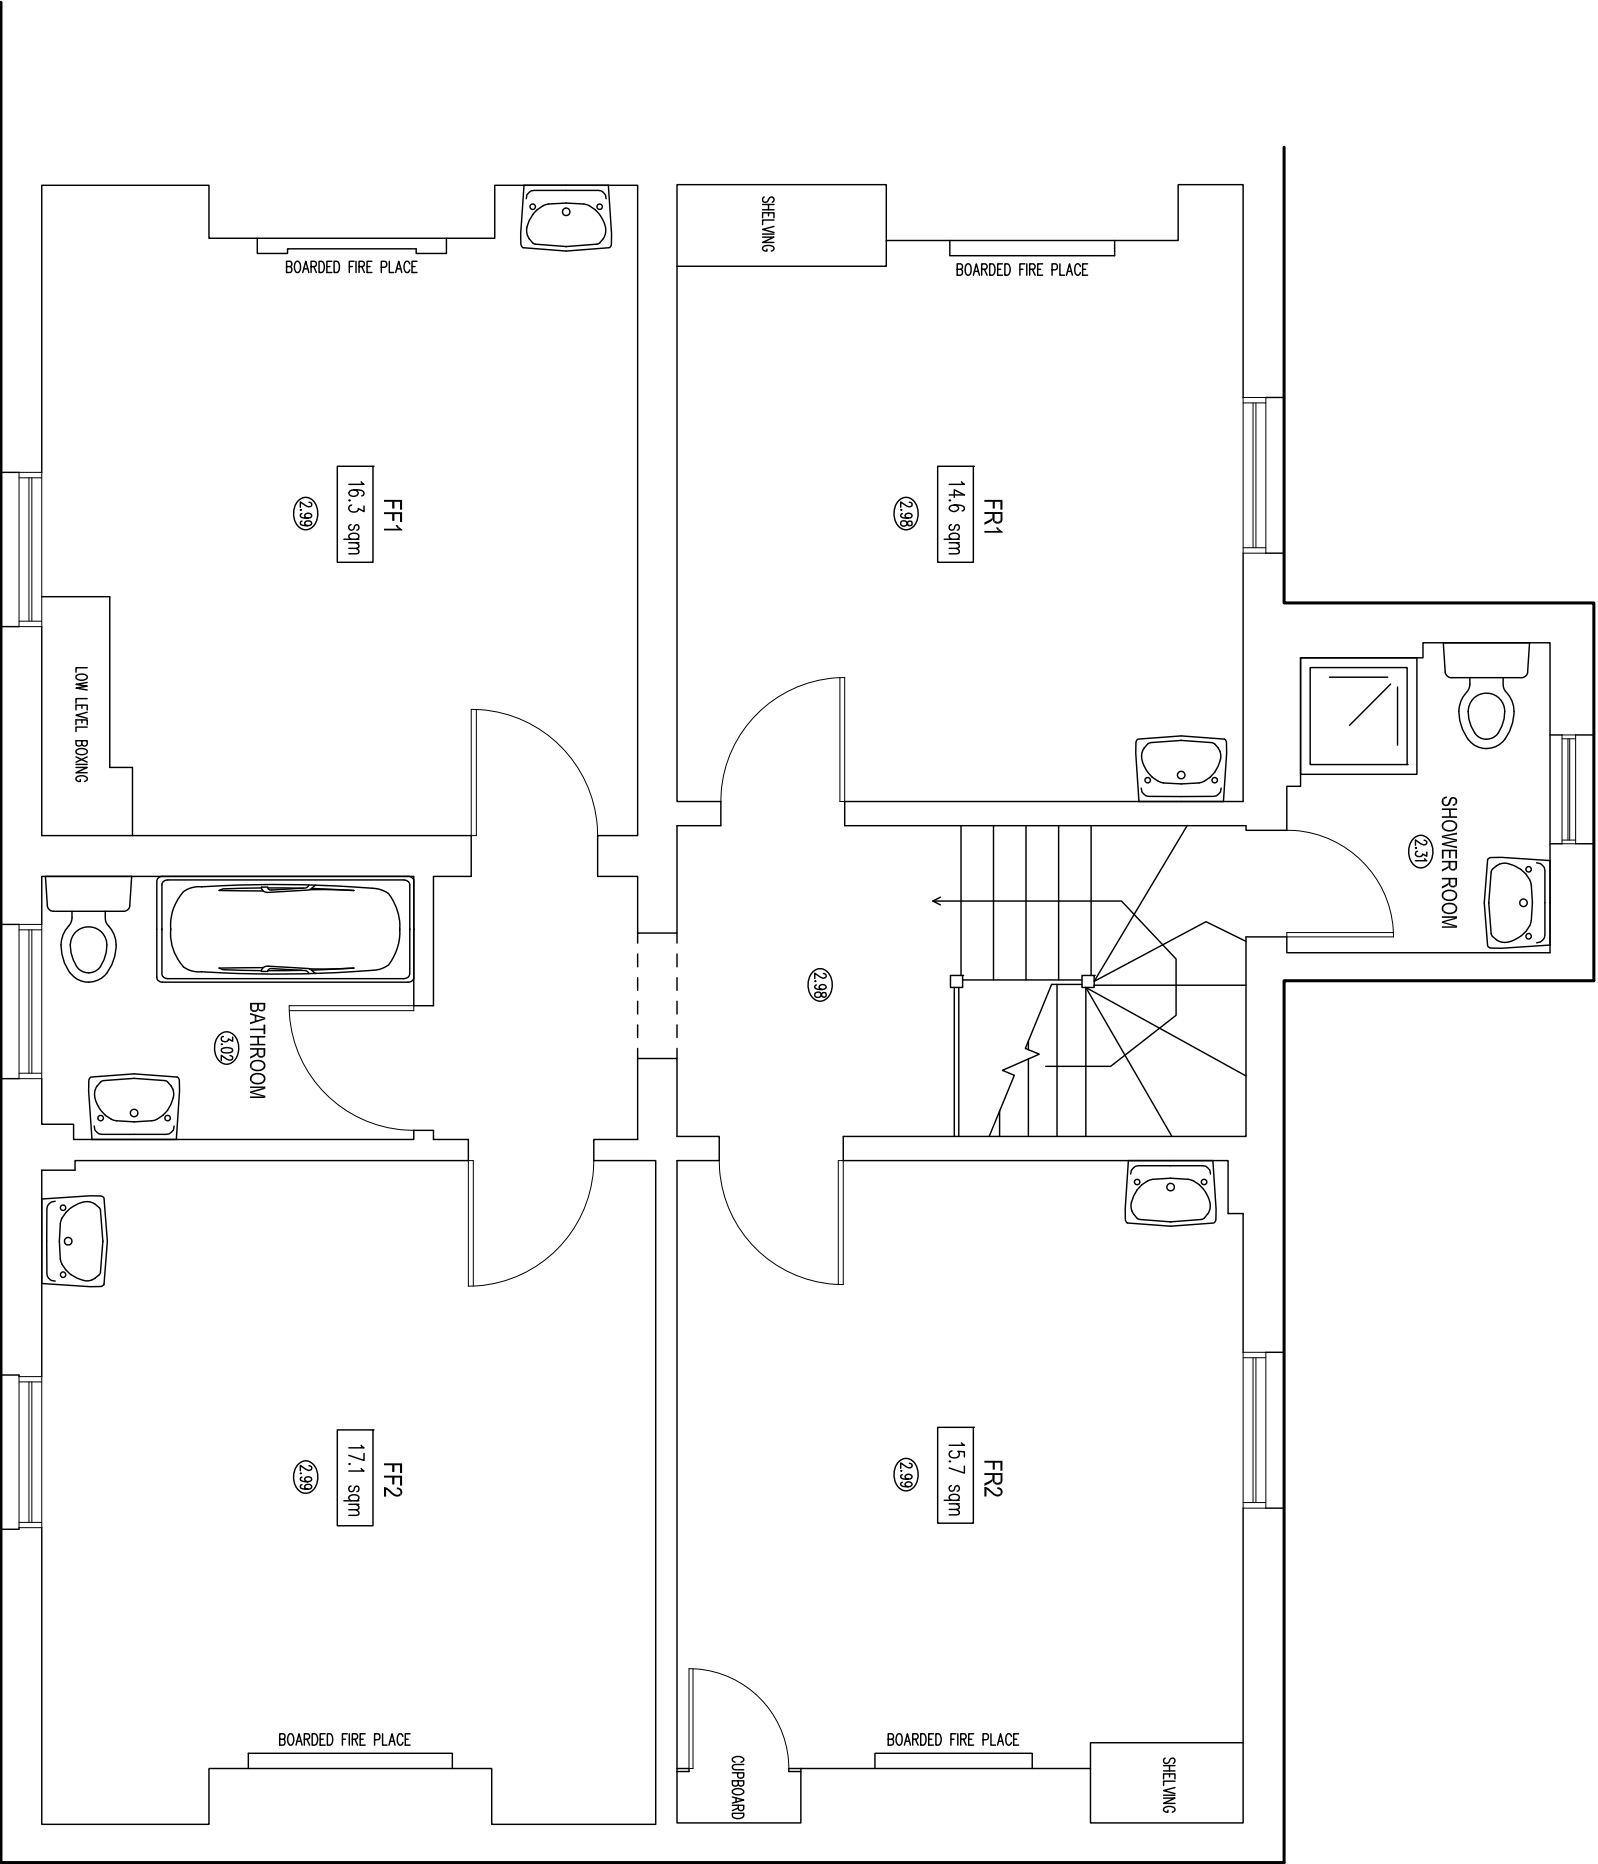


- LEGEND
- Telephone Socket
  - Fire Alarm Break Glass
  - Fire Alarm Sounder
  - Smoke Detector
  - Illuminated Fire Exit Sign
  - Single Supply Socket
  - Double Supply Socket
  - Single Gang Light Switch
  - Pullcord Switch
  - Radiator
  - Key symbol for Direction
  - Key symbol for Up Direction
  - Key symbol for Down Direction
  - Key symbol for Floor To Ceiling Heights
  - Key symbol for Floor To Ceiling Heights
  - Change in Floor Construction etc
  - Hidden Detail Under Stairs etc
  - "Overhead" Beams, Roof Lights etc
  - Single Gang Light Switch
  - Height of window sill and window head from TL
  - SILL 1.00
  - HEAD 2.00

NOTES

SURVEY TIED INTO NATIONAL GRID OSTN42 AND OSG402 DATUM FOR HEIGHT USING GPS EQUIPMENT UTILIZING THE TRIMBLE VRS NOW SYSTEM FOR REAL TIME KINEMATIC (RTK) CORRECTIONS NATIONAL GRID SCALE FACTOR HAS NOT BEEN APPLIED TO THE SURVEY UNLESS SPECIFIED

DRAINAGE AND SERVICE INFORMATION SHOWN ON THIS SURVEY HAS BEEN OBTAINED BY VISUAL INSPECTION ONLY, ALTHOUGH ALL POSSIBLE CARE HAS BEEN TAKEN TO ENSURE THAT DETAILS SHOWN ARE CORRECT, WE ARE UNABLE TO ACCEPT ANY RESPONSIBILITY FOR COSTS ARISING OUT OF ANY ERRORS OR OMISSIONS. COPYRIGHT: THIS DRAWING MAY NOT BE REPRODUCED IN ANY FORM WHATSOEVER WITHOUT THE CONSENT OF C J SURVEYS LTD.

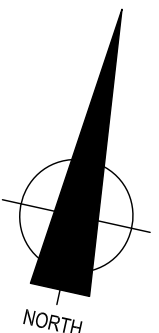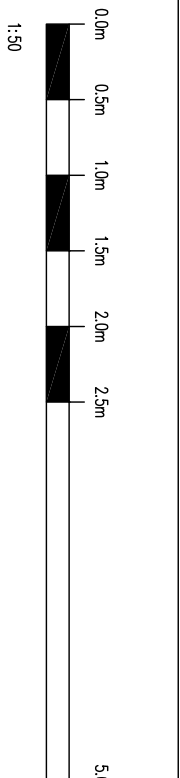

**C J SURVEYS LTD**  
LAND | BUILDING | ENGINEERING  
PROFESSIONAL MEASURED SURVEYS  
Tel: 01638 591031 Mobile: 07845 775645  
Web: www.cjsurveys.co.uk Email: mail@cjsurveys.co.uk

CLIENT: QUEENS COLLEGE

DATE	DRAWN	SHEET SIZE SCALE
MARCH 2019	GS/CJ	A1 1:50

PROJECT: BASEMENT, GROUND & FIRST FLOOR LAYOUT PLANS

No.65 PANTON STREET, CAMBRIDGE

DRAWING NO. 02619P52