




BASEMENT FLOOR PLAN

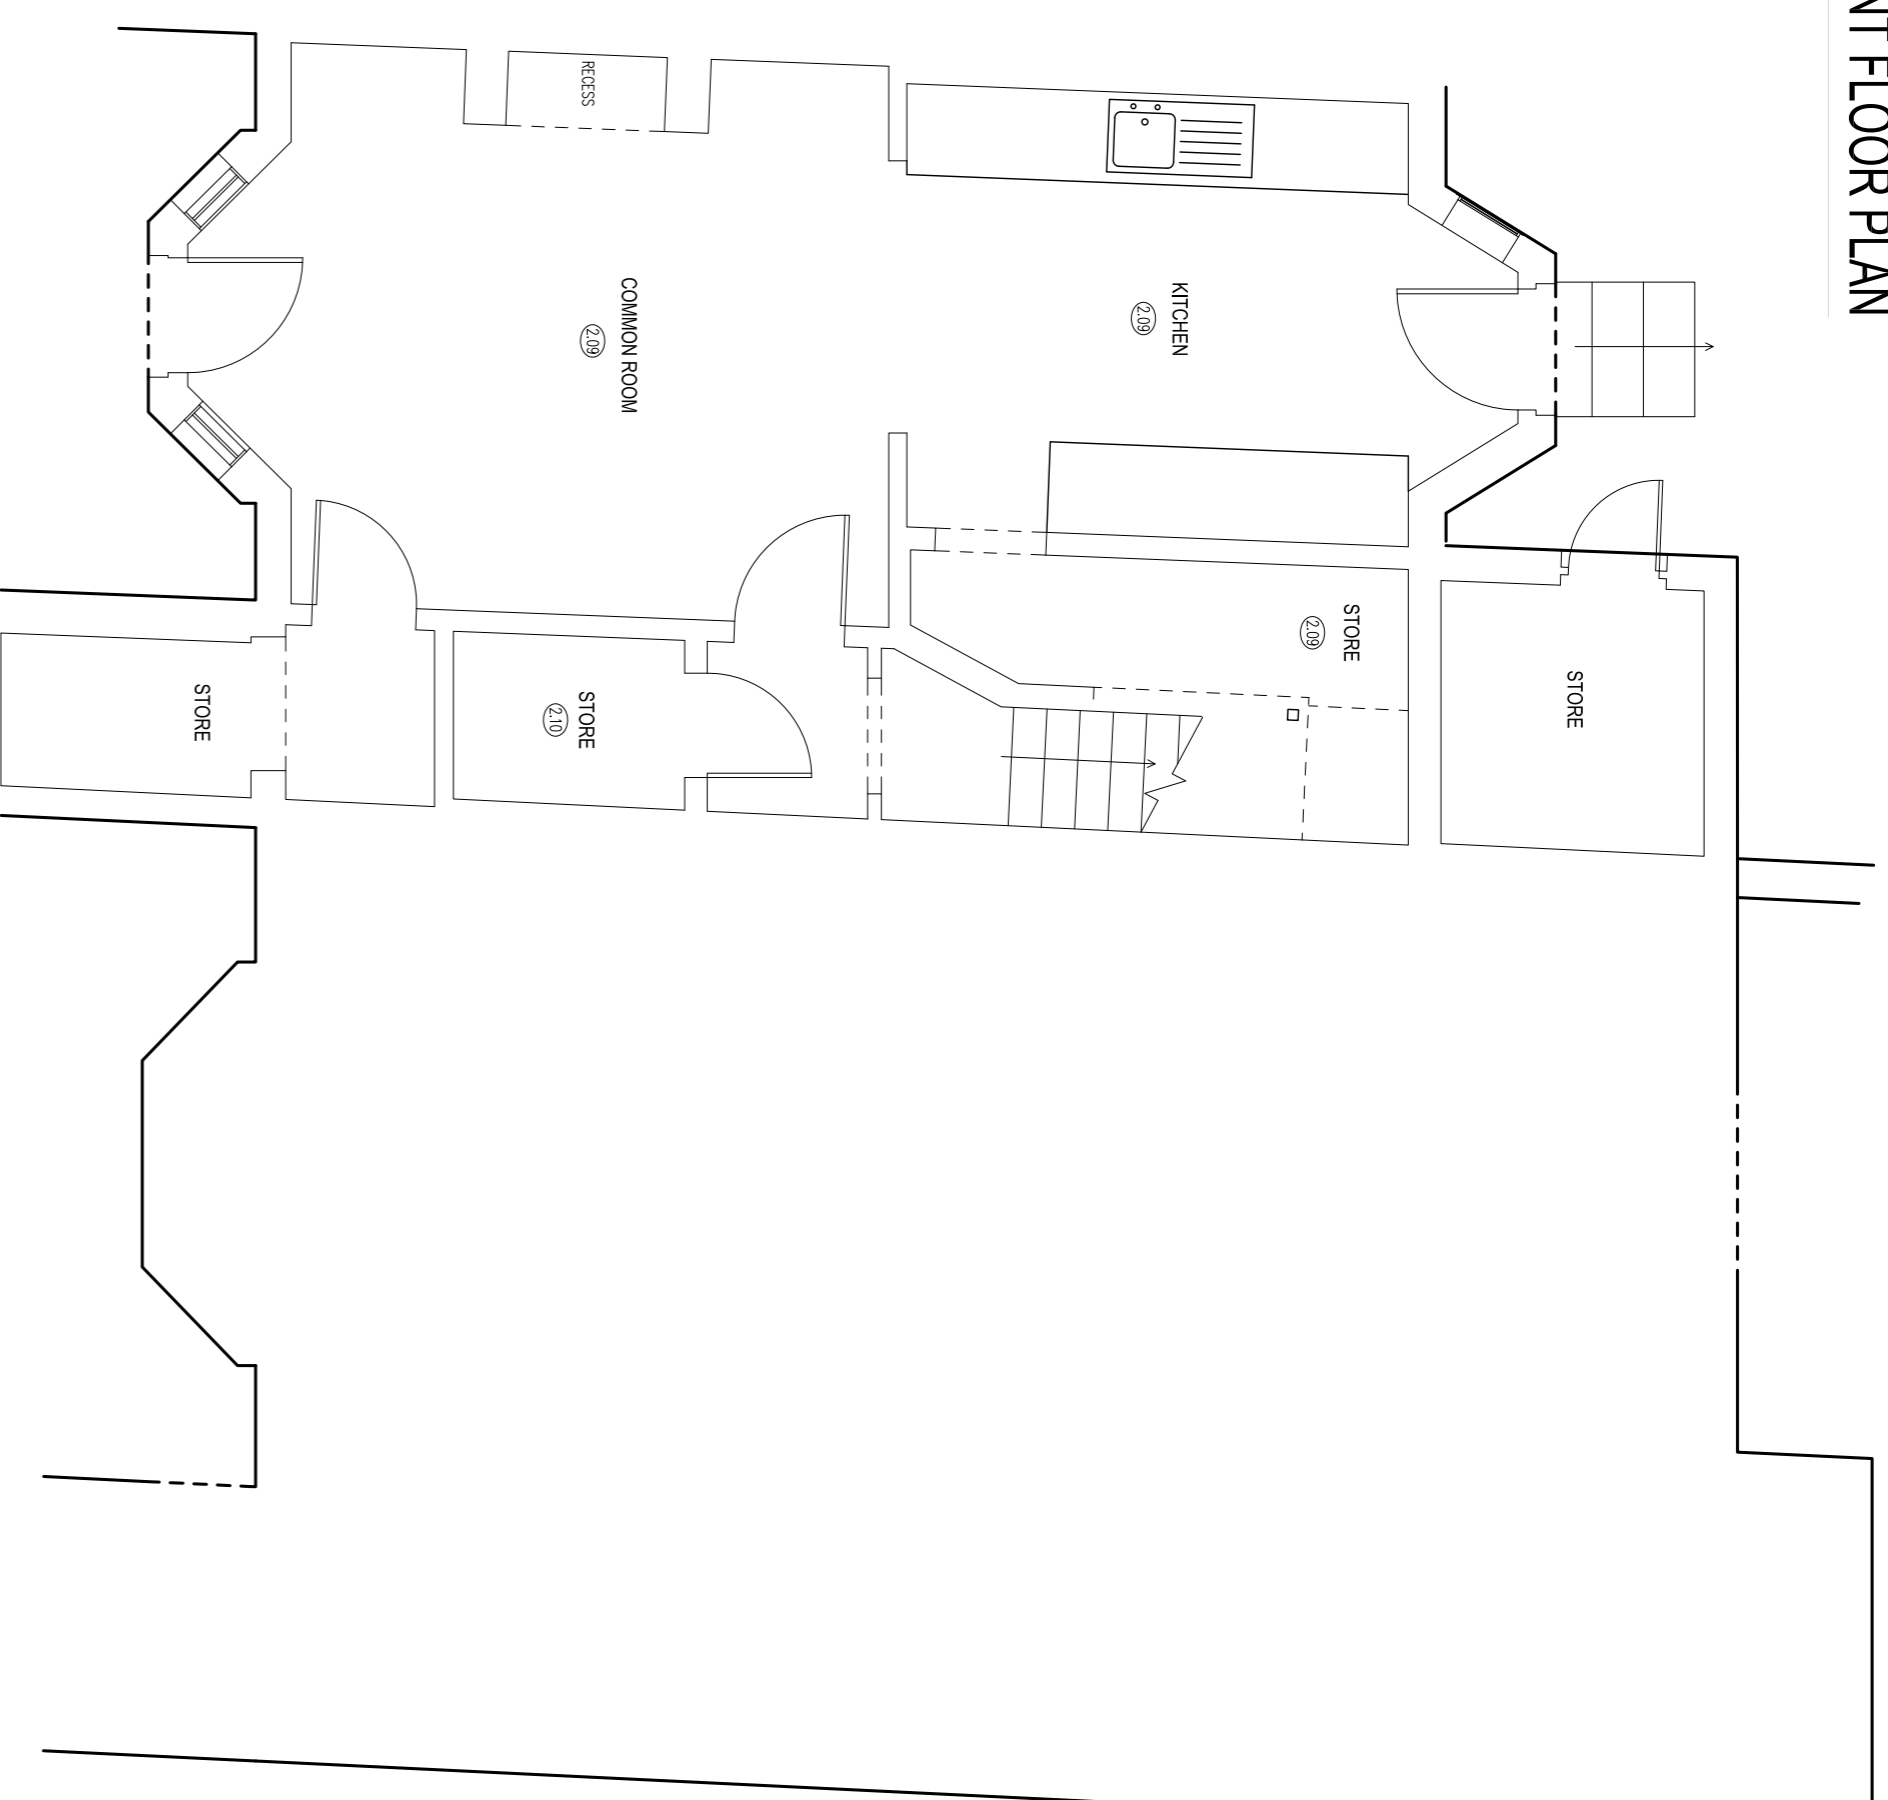

GROUND FLOOR PLAN

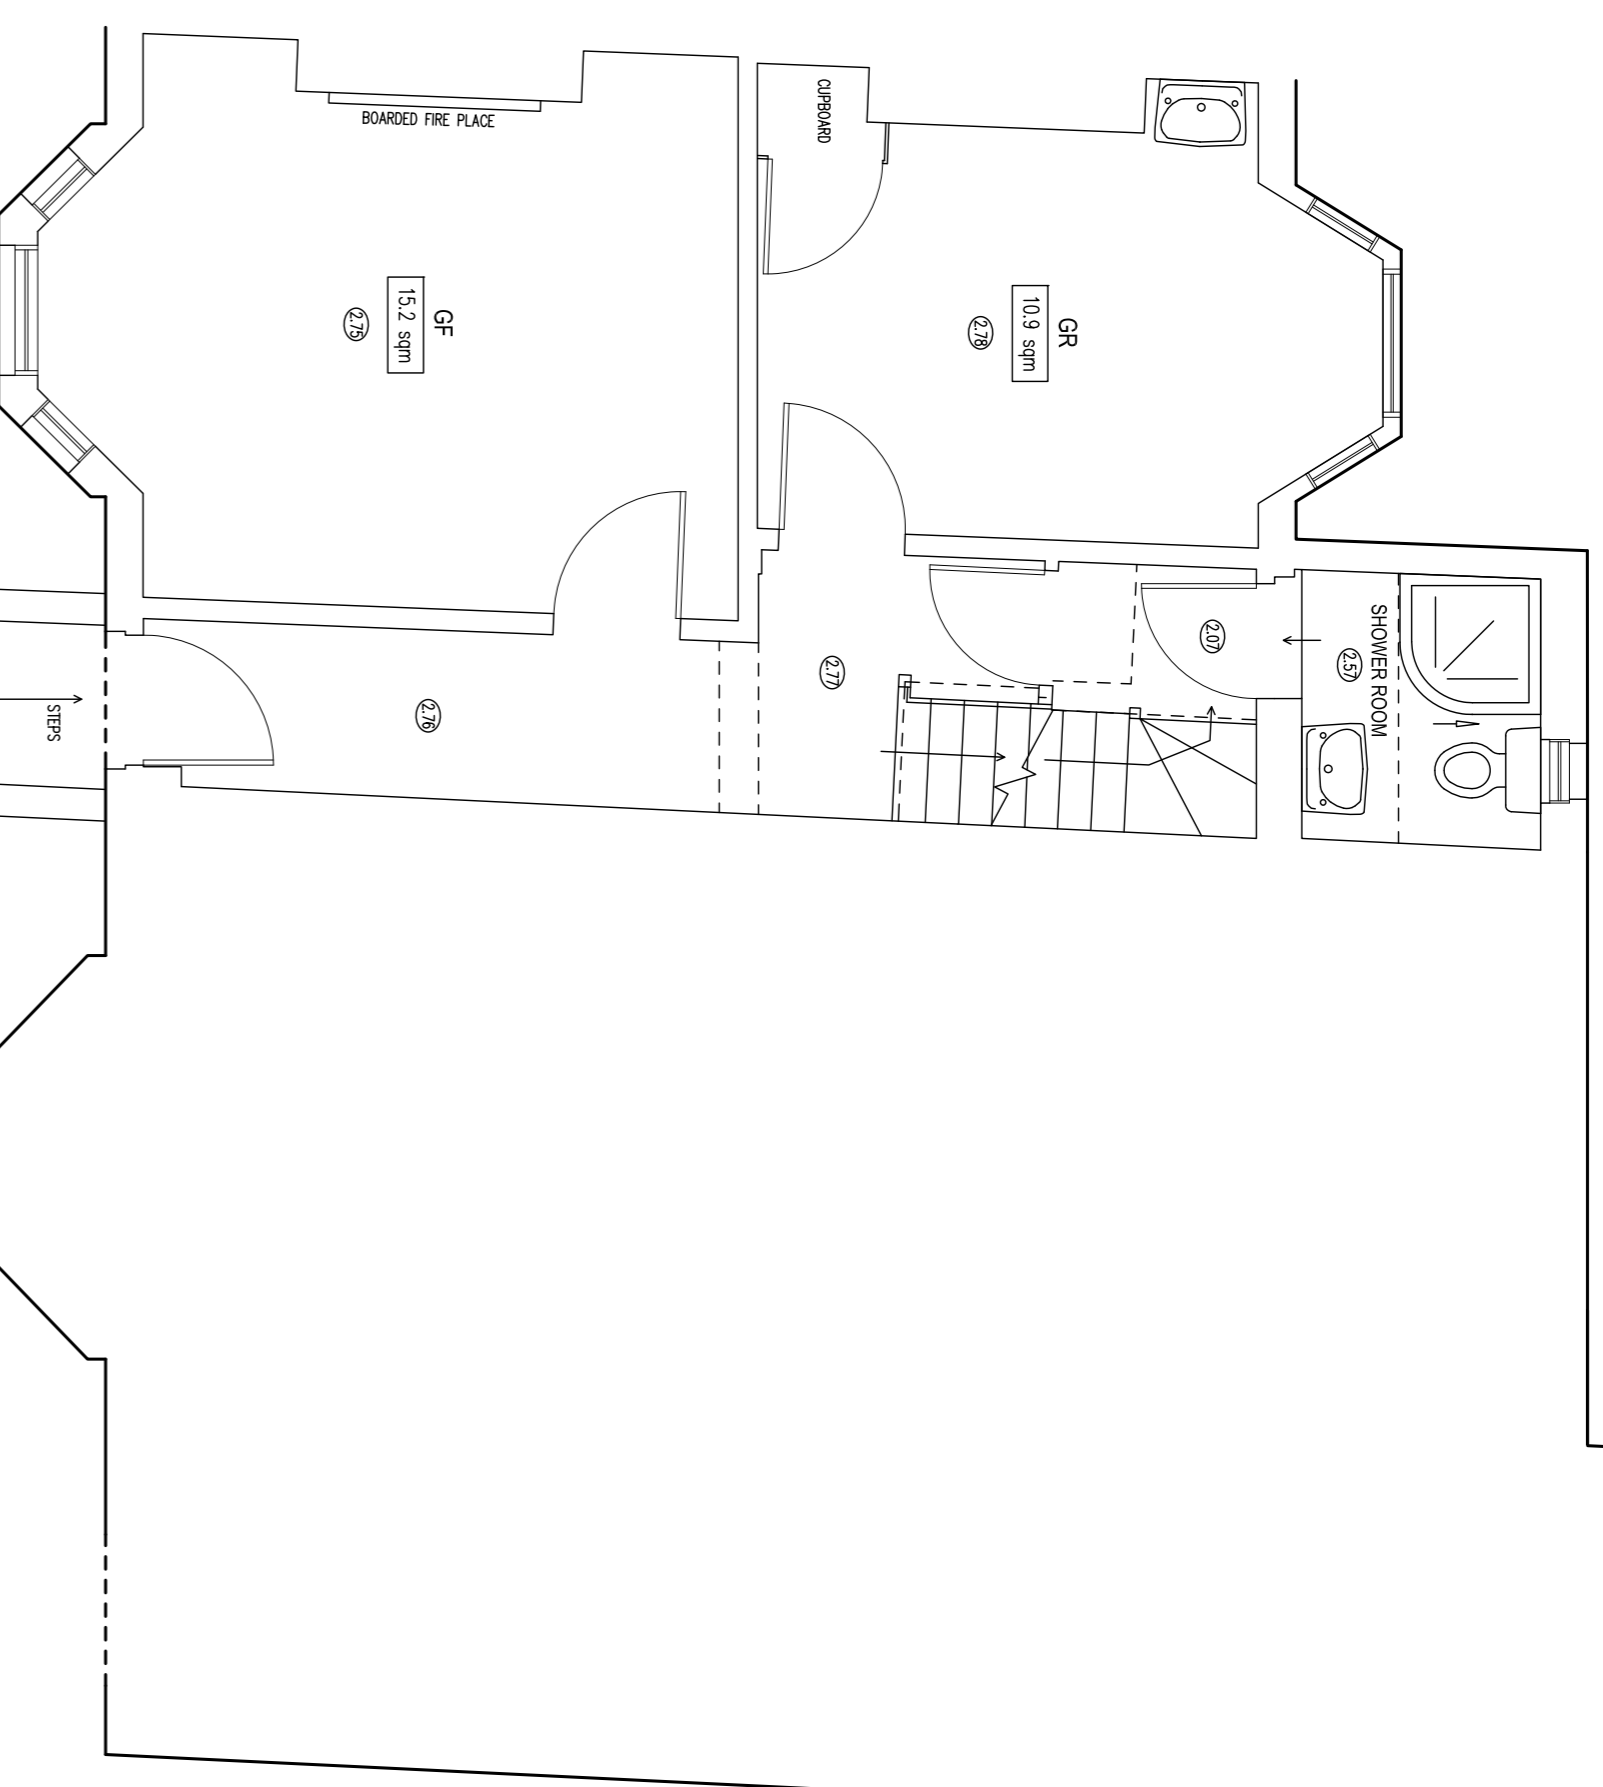



FIRST FLOOR PLAN

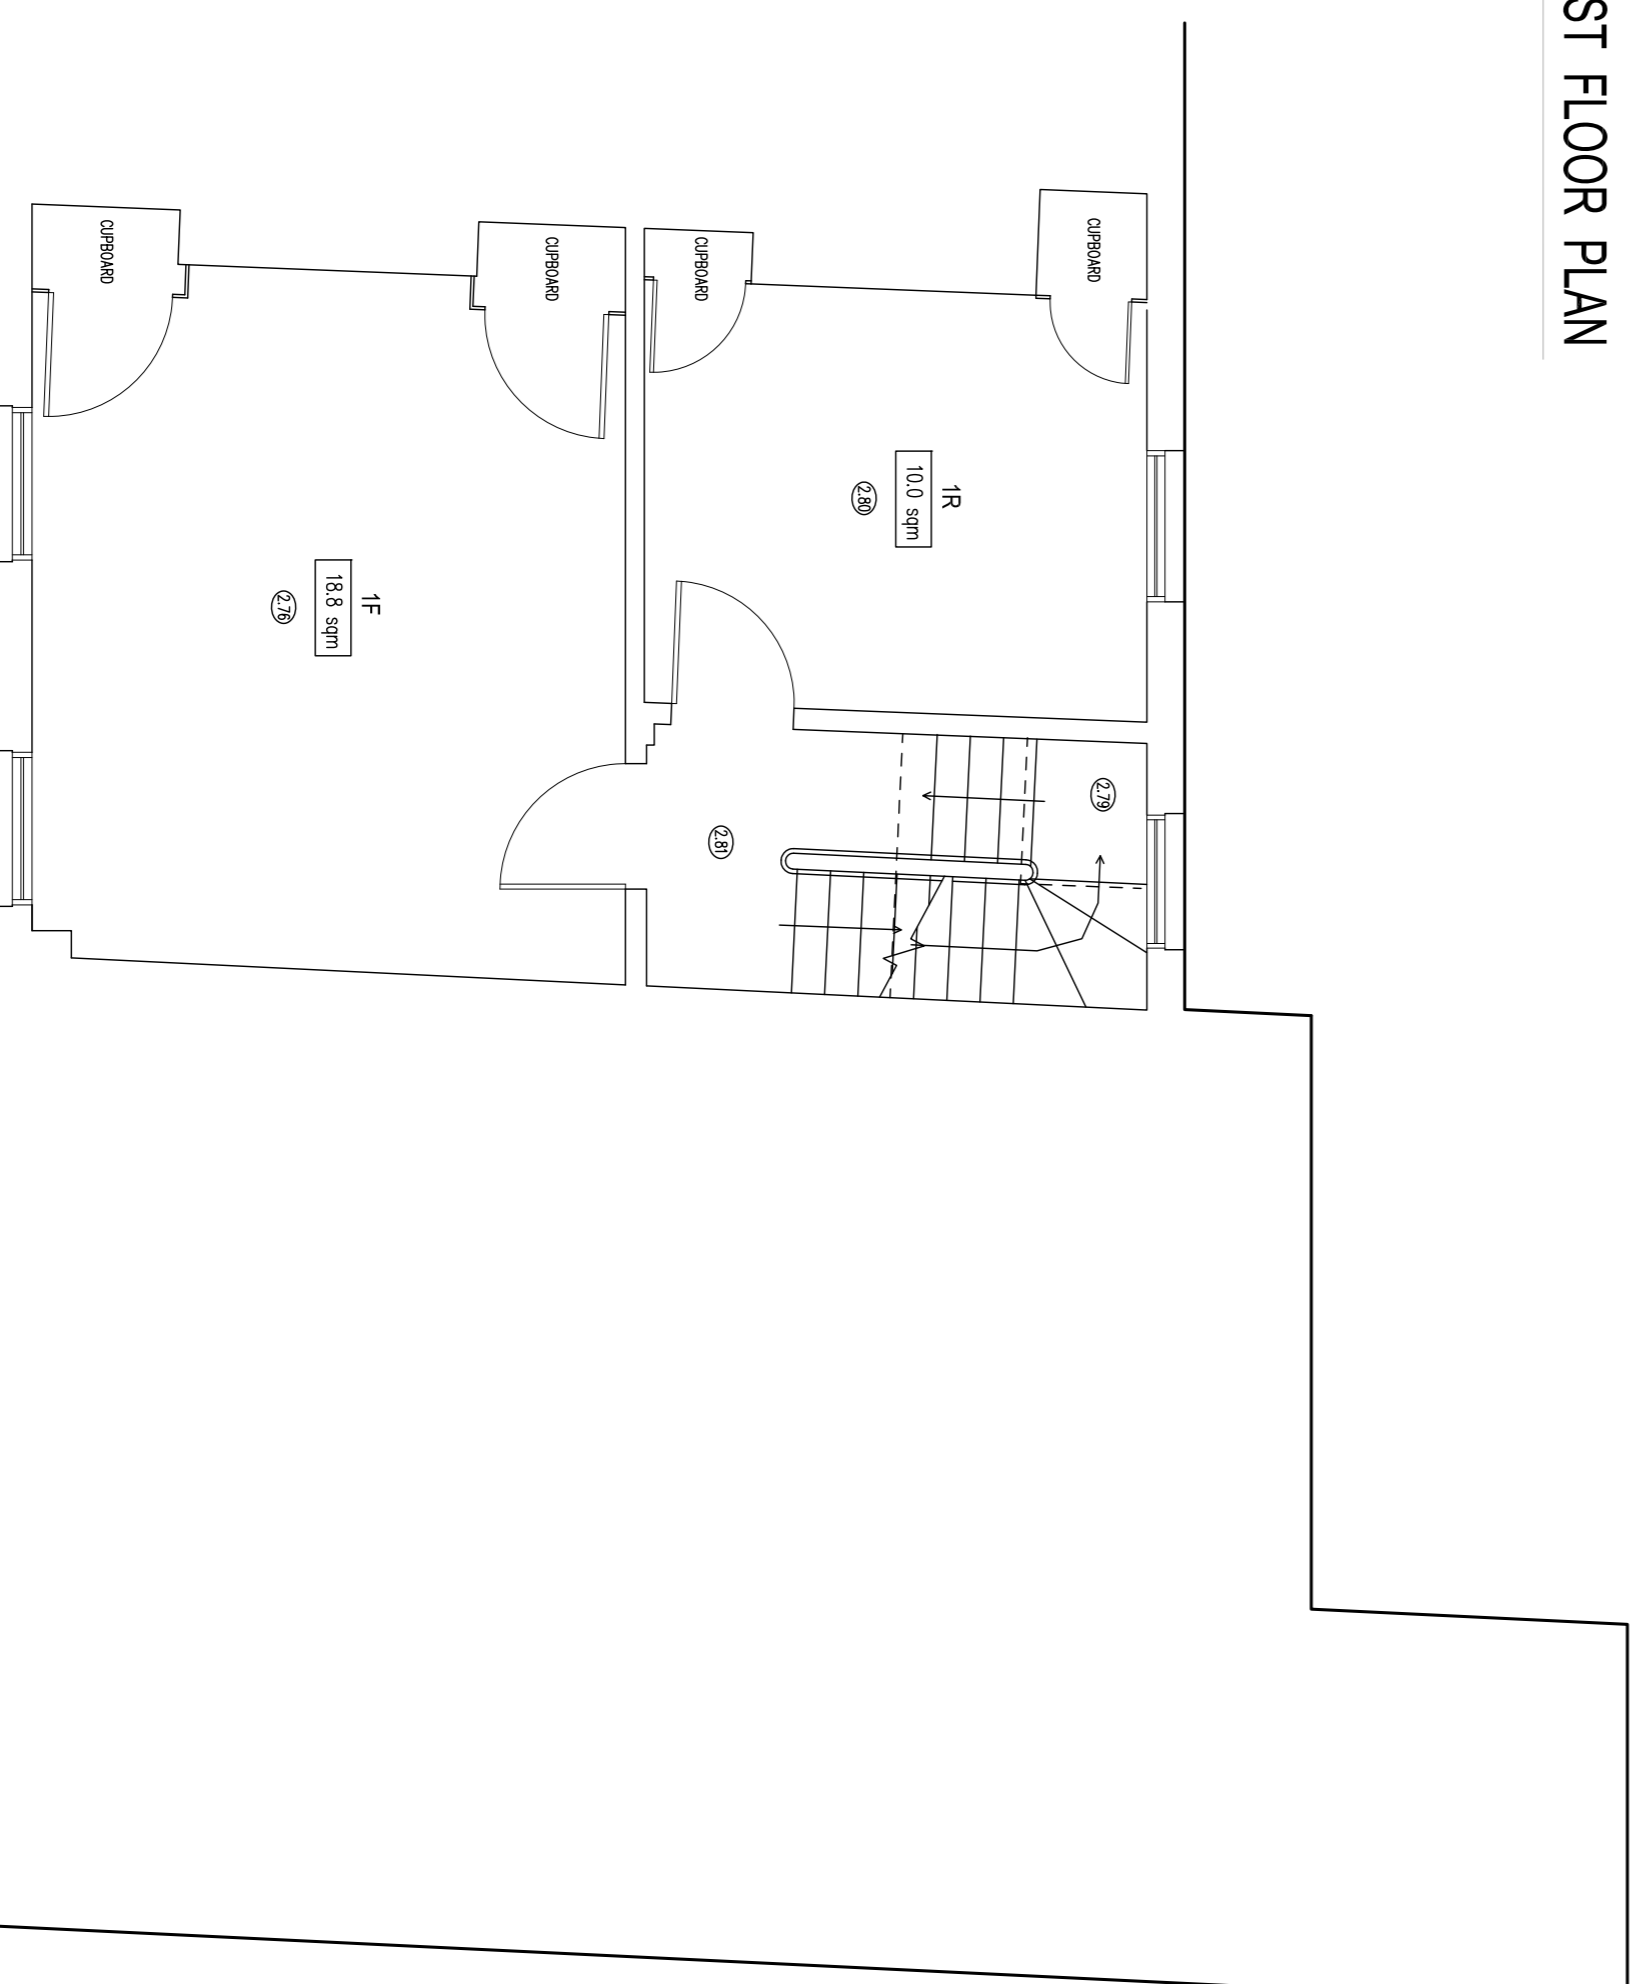

SECOND FLOOR PLAN



	Telephone Socket		Key symbol for Direction
	Ether Net Socket		Key symbol for 10 Ceiling Heights
	TV Aerial Socket		Key symbol for Under Stairs etc
	Fire Alarm Break Glass		Key symbol for Fire Exit Sign
	Fire Alarm Sounder		Key symbol for Single Supply Socket
	Fire Alarm Indicator		Key symbol for Single Long Light Switch
	Smoke Detector		Radiator
	Illuminated Fire Exit Sign		
	Single Supply Socket		
	Double Supply Socket		
	Single Long Light Switch		
	Radiator		
			Key symbol for Change in Floor Construction etc
			Key symbol for Hidden Detail Under Stairs etc
			Key symbol for Overhead Beams, Roof Lights etc
			Key symbol for Finished floor level value
			Key symbol for Height of window sill and window head from Fin TL
			SILL 1.00
			HEAD 2.00

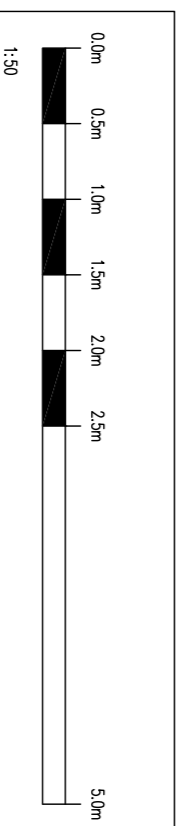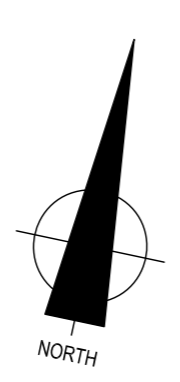

NOTES

SURVEY TIED INTO NATIONAL GRID OSTN102 AND OSGM02 DATUM FOR HEIGHT USING GPS EQUIPMENT UTILIZING THE TRIMBLE VRS NOW SYSTEM FOR REAL TIME KINEMATIC (RTK) CORRECTIONS NATIONAL GRID SCALE FACTOR HAS NOT BEEN APPLIED TO THE SURVEY UNLESS SPECIFIED

DRAINAGE AND SERVICE INFORMATION SHOWN ON THIS SURVEY HAS BEEN OBTAINED BY VISUAL INSPECTION ONLY, ALTHOUGH ALL POSSIBLE CARE HAS BEEN TAKEN TO ENSURE THAT DETAILS SHOWN ARE CORRECT, WE ARE UNABLE TO ACCEPT ANY RESPONSIBILITY FOR COSTS ARISING OUT OF ANY ERRORS OR OMISSIONS. COPYRIGHT: THIS DRAWING MAY NOT BE REPRODUCED IN ANY FORM WHATSOEVER WITHOUT THE CONSENT OF C J SURVEYS LTD.

C J SURVEYS LTD		CLIENT: QUEENS COLLEGE	
LAND BUILDING ENGINEERING PROFESSIONAL MEASURED SURVEYS			
Tel: 01638 591031 Mobile: 07945 779645 Web: www.cjsurveys.co.uk Email: mail@cjsurveys.co.uk			
DATE	DRAWN	SHEET SIZE	SCALE
MARCH 2019	GS/CJ	A1	1:50
PROJECT: BASEMENT, GROUND, FIRST & SECOND FLOOR LAYOUT PLANS			DRAWING NO. 02619P53