


THIRD FLOOR PLAN

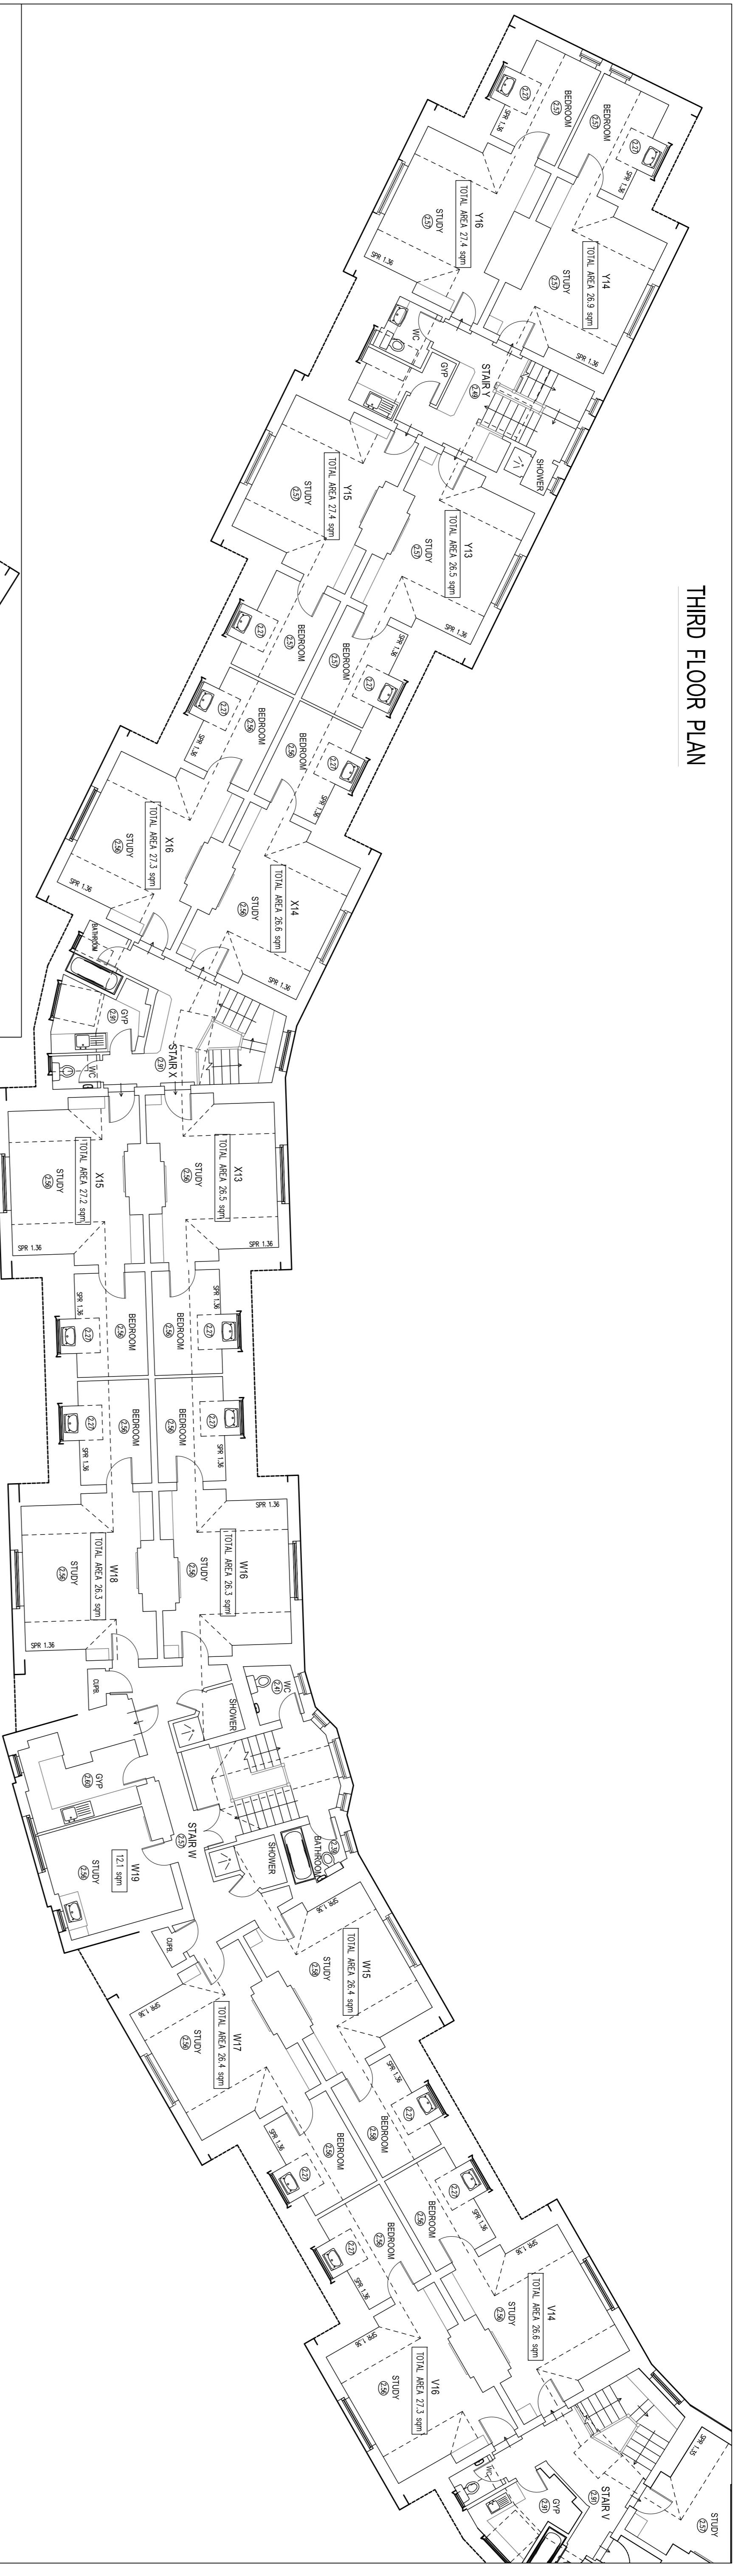


THIRD FLOOR PLAN



LEGEND

- Telephone Socket
- Fire Alarm Break Glass
- Fire Alarm Sounder
- Smoke Detector
- Illuminated Fire Exit Sign
- Single Supply Socket
- Double Supply Socket
- Single Core Light Switch
- Radial Switch
- Router
- Key Symbol for Direction of Stairs, Floor etc
- Key Symbol for Floor to Ceiling Heights
- Key Symbol for Floor to Ceiling Heights with W & S
- Change in Floor Construction etc
- Hidden Wall/Liner Stairs etc
- Turnover/ Beam/ Road Lights etc
- Fringed floor level value
- Height of window sill and window head from FL

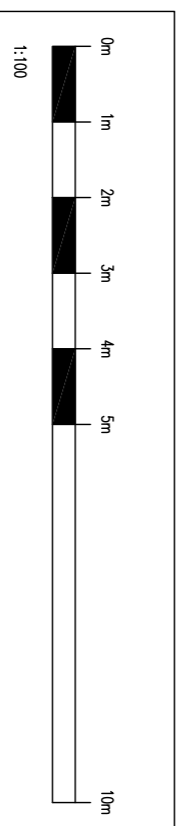

NOTES

SURVEY TIED INTO NATIONAL GRID OSTN22 AND OSGM22 DATA FOR HEIGHT USING GPS EQUIPMENT UTILIZING THE TRIMBLE VRS NOW SYSTEM FOR REAL TIME KINEMATIC (RTK) CORRECTIONS NATIONAL GRID SCALE FACTOR HAS NOT BEEN APPLIED TO THE SURVEY UNLESS SPECIFIED

DRAINAGE AND SERVICE INFORMATION SHOWN ON THIS SURVEY HAS BEEN OBTAINED BY VISUAL INSPECTION ONLY, ALTHOUGH ALL POSSIBLE CARE HAS BEEN TAKEN TO ENSURE THAT DETAILS SHOWN ARE CORRECT. WE ARE UNABLE TO ACCEPT ANY RESPONSIBILITY FOR COSTS ARISING OUT OF ANY ERRORS OR OMISSIONS. COPYRIGHT: THIS DRAWING MAY NOT BE REPRODUCED IN ANY FORM WHATSOEVER WITHOUT THE CONSENT OF CJ SURVEYS LTD.

**C J SURVEYS LTD**  
**LAND | BUILDING | ENGINEERING**  
**PROFESSIONAL MEASURED SURVEYS**

CLIENT QUEENS COLLEGE

PROJECT THIRD FLOOR LAYOUT PLAN  
 FISHER BUILDING, QUEENS COLLEGE, CAMBRIDGE

DATE	DRAWN	SHEET SIZE
MAY 2019	GS/CJ	A1
		SCALE
		1:100
		DRAWING NO.
		03919F54