



FIRST FLOOR PLAN

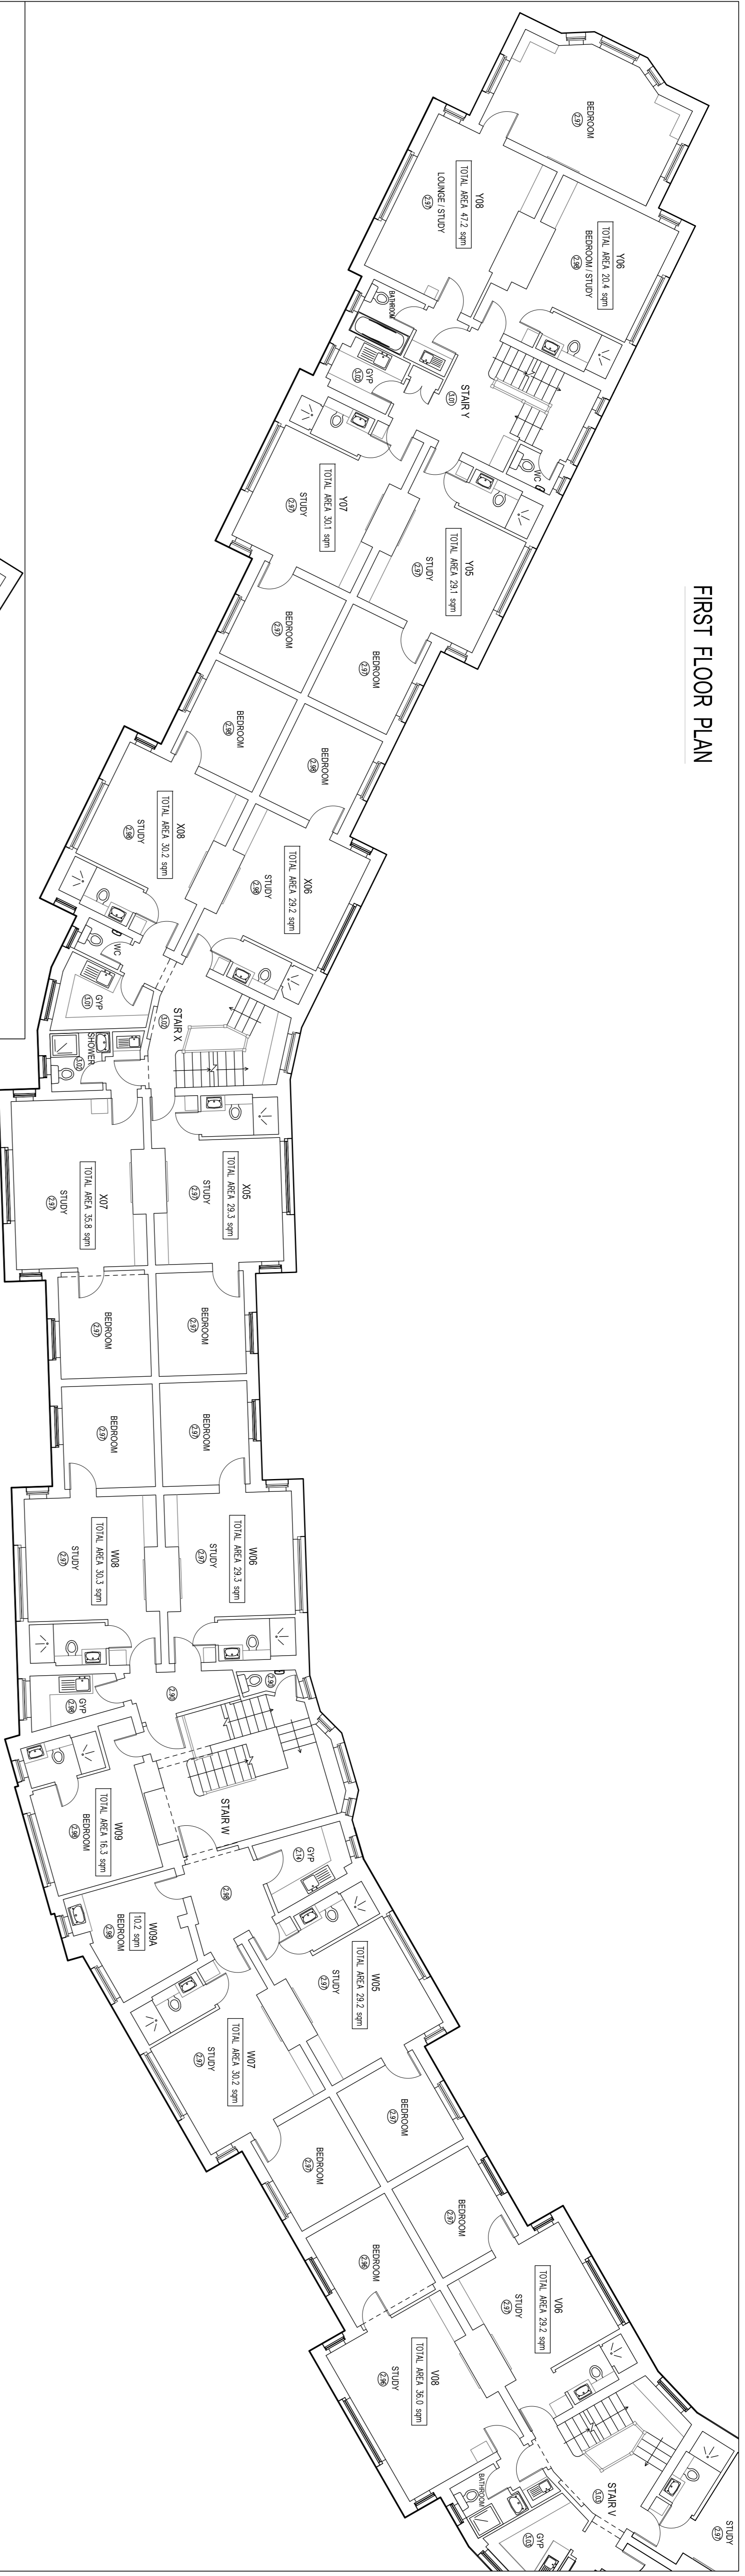


FIRST FLOOR PLAN

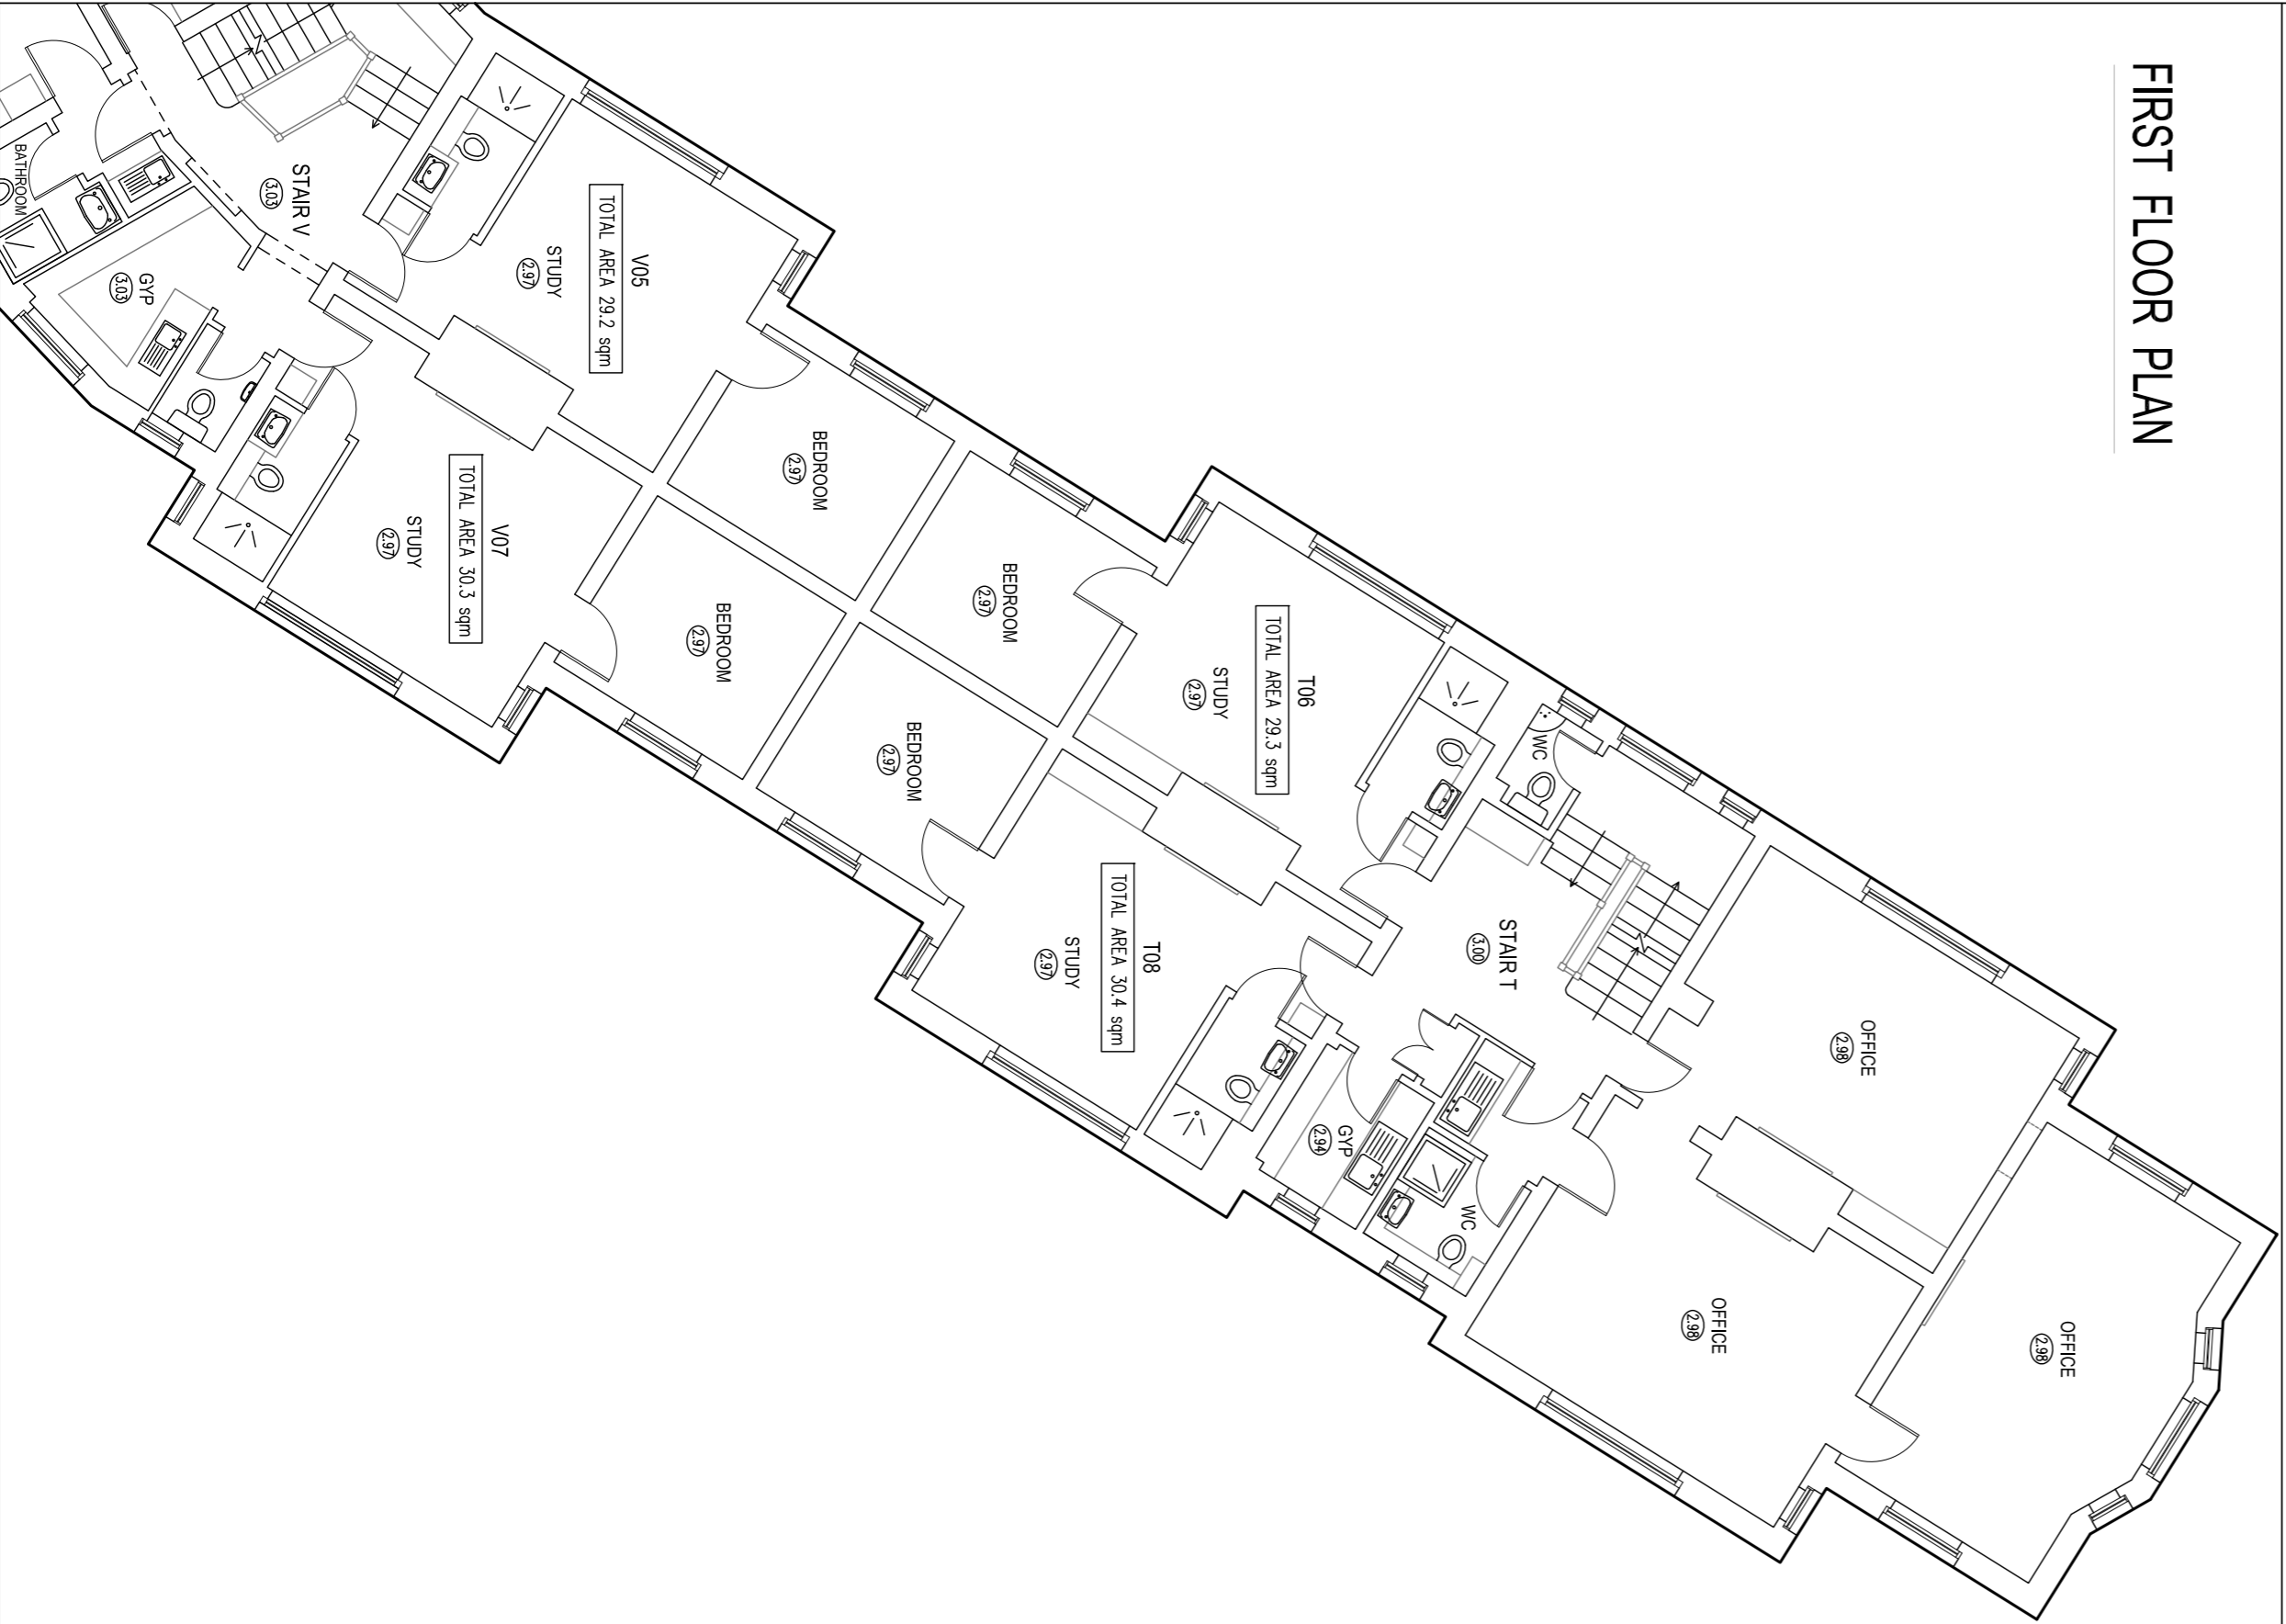

LEGEND

⬇	Telephone Socket	⬆	Key Symbol For Direction Of Stairs, Floors etc
⬇	Elter Mtl Socket	⬆	Key Symbol For Floor To Ceiling Heights
⬇	TV Aerial Socket	⬆	Key Symbol For Floor To Ceiling Heights
⬇	Fire Alarm Break Glass	⬆	Change In Floor Construction etc
⬇	Fire Alarm Sounder	⬆	'Hidden' Detail' Under Stairs etc
⬇	Fire Extinguisher	⬆	'Tombston' Beams, Road Lights etc
⬇	Smoke Detector	⬆	Faded floor level value
⬇	Smoke Detector	⬆	Height of window sill and window head from FL
⬇	Illuminated Fire Exit Sign	⬆	
⬇	Single Supply Socket	⬆	
⬇	Double Supply Socket	⬆	
⬇	Single core Light Switch	⬆	
⬇	Radial Switch	⬆	
⬇	Router	⬆	

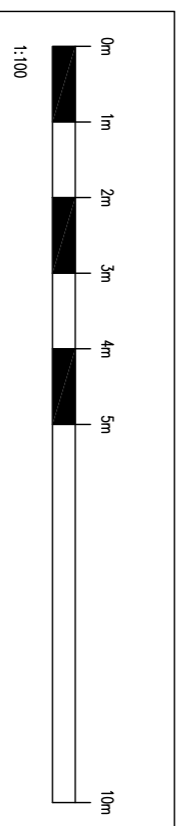

NOTES

SURVEY TIED INTO NATIONAL GRID OSTN12 AND OSN4022 DATA FOR HEIGHT USING GPS EQUIPMENT UTILIZING THE TRIMBLE VRS NOW SYSTEM FOR REAL TIME KINEMATIC (RTK) CORRECTIONS NATIONAL GRID SCALE FACTOR HAS NOT BEEN APPLIED TO THE SURVEY UNLESS SPECIFIED

DRAINAGE AND SERVICE INFORMATION SHOWN ON THIS SURVEY HAS BEEN OBTAINED BY VISUAL INSPECTION ONLY, ALTHOUGH ALL POSSIBLE CARE HAS BEEN TAKEN TO ENSURE THAT DETAILS SHOWN ARE CORRECT, WE ARE UNABLE TO ACCEPT ANY RESPONSIBILITY FOR COSTS ARISING OUT OF ANY ERRORS OR OMISSIONS. COPYRIGHT: THIS DRAWING MAY NOT BE REPRODUCED IN ANY FORM WHATSOEVER WITHOUT THE CONSENT OF C J SURVEYS LTD.

C J SURVEYS LTD
LAND | BUILDING | ENGINEERING
PROFESSIONAL MEASURED SURVEYS

CLIENT: QUEENS COLLEGE

PROJECT: FIRST FLOOR LAYOUT PLAN
 FISHER BUILDING, QUEENS COLLEGE, CAMBRIDGE

DATE: MAY 2019
 DRAWN: G.S.C.J.
 SHEET SIZE SCALE: A1 1:100
 DRAWING NO.: 03919F52

Tel: 01638 591031 Mobile: 07945 779645
 Web: www.cjsurveys.co.uk Email: me@cjsurveys.co.uk