




GROUND FLOOR PLAN

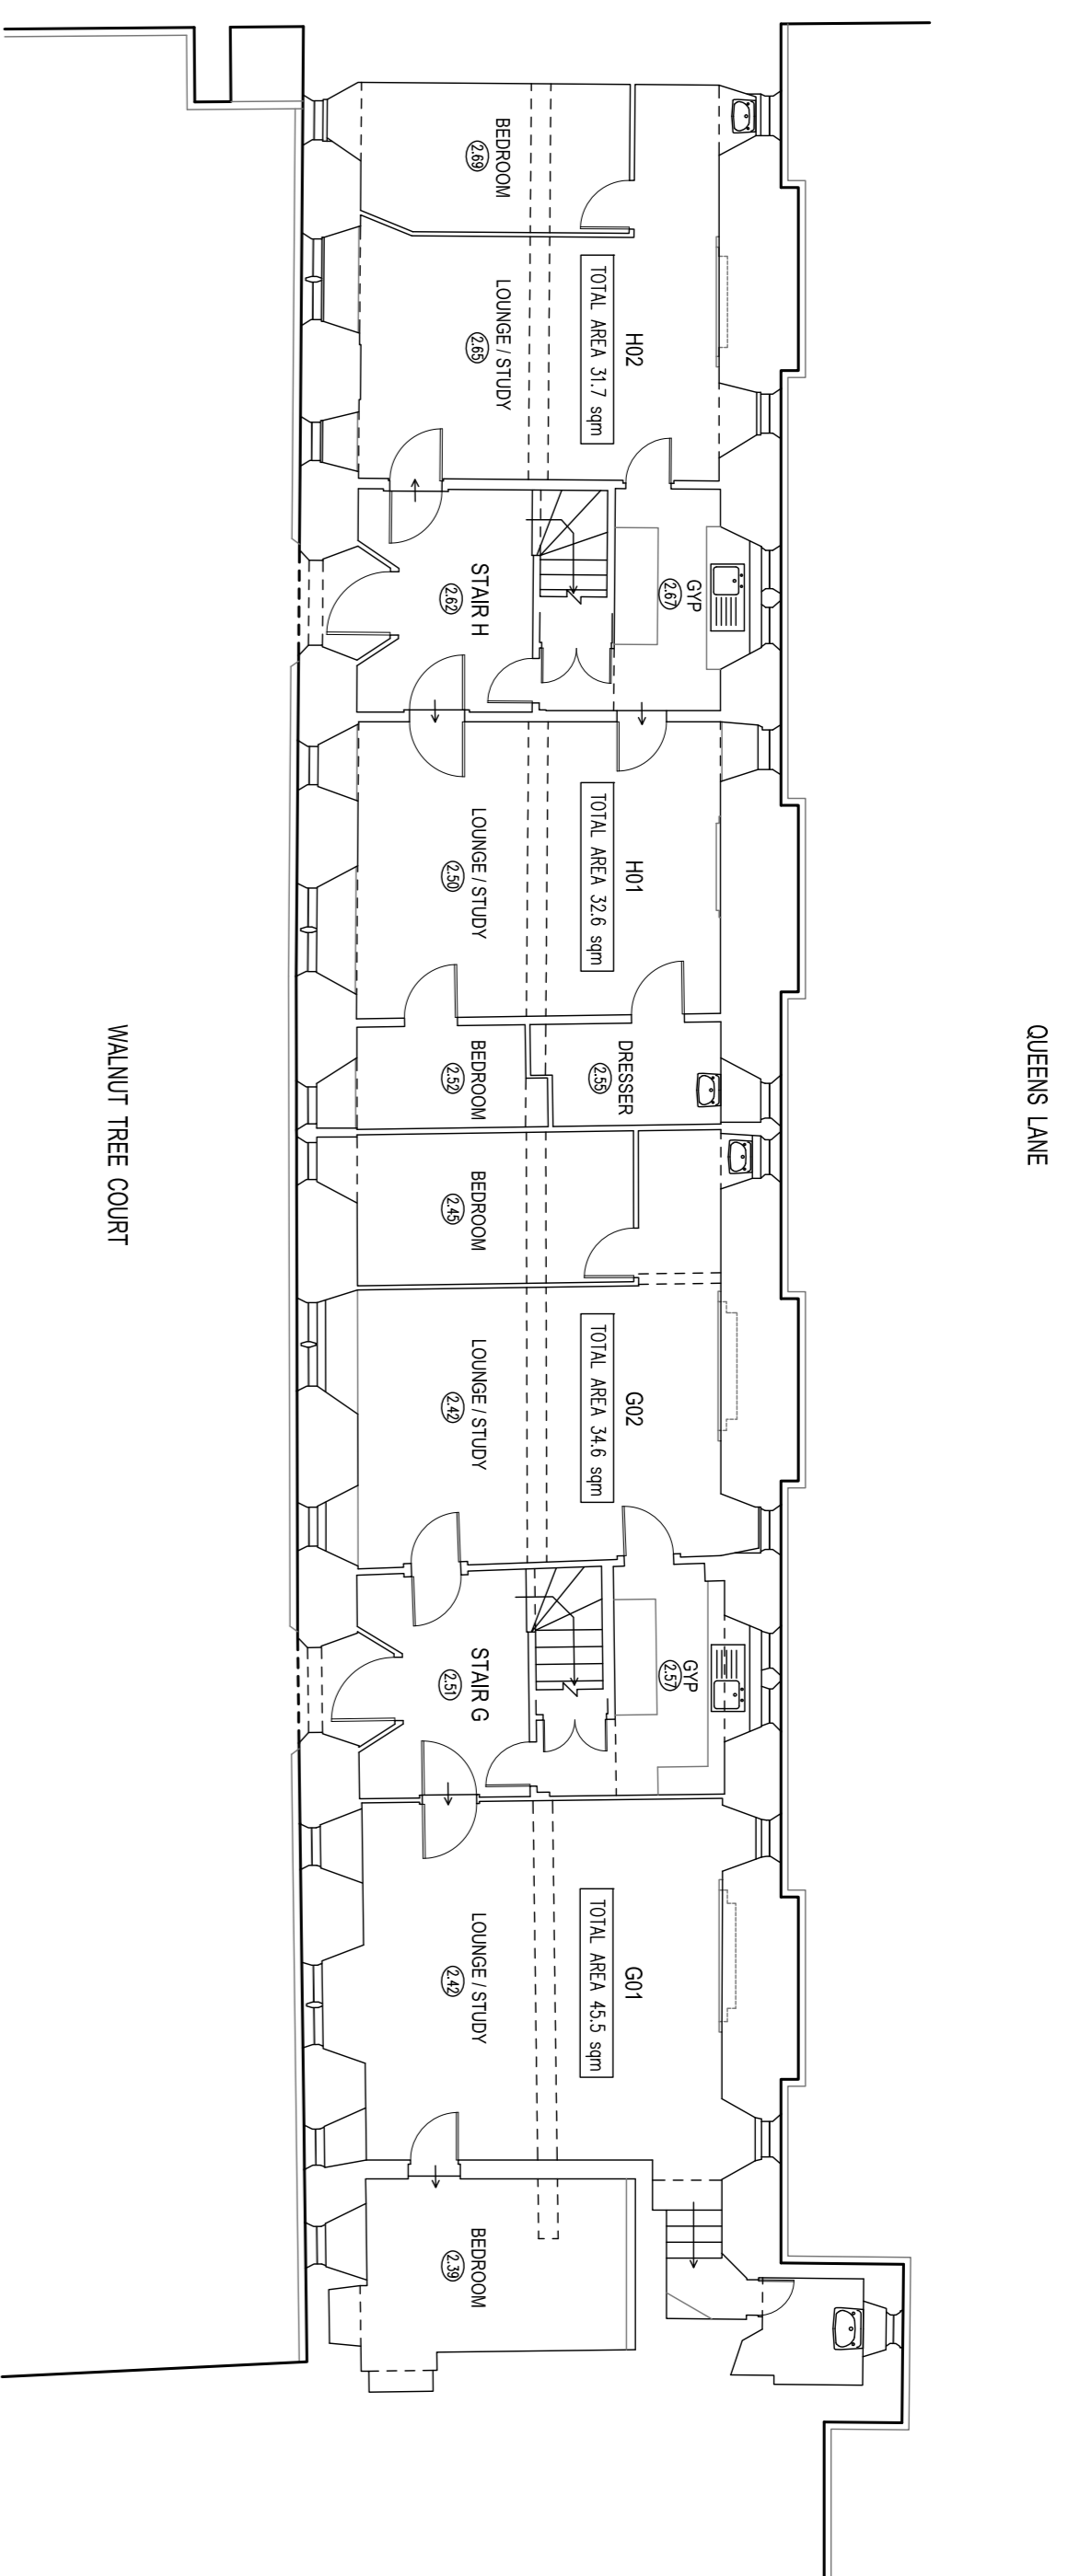

FIRST FLOOR PLAN


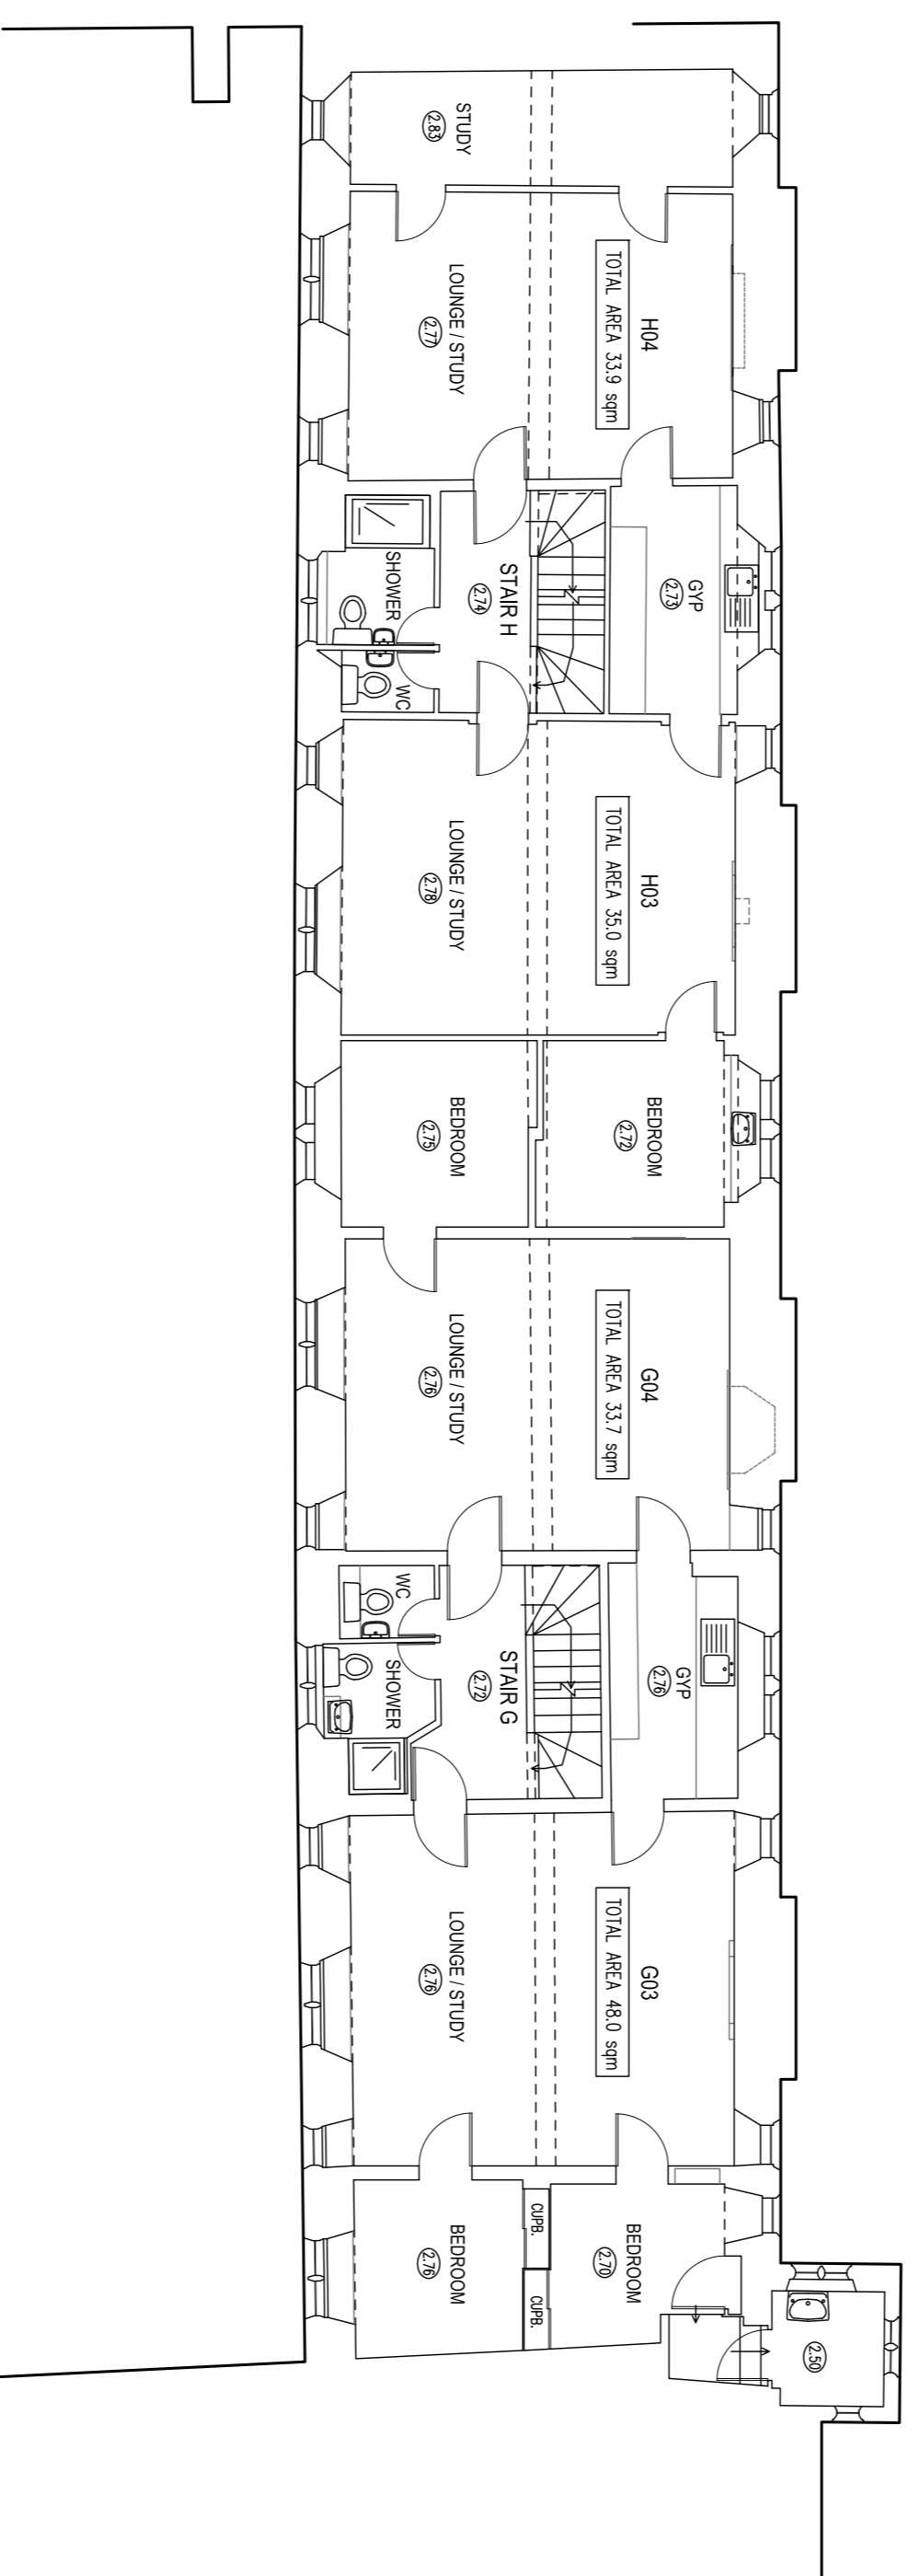


SECOND FLOOR PLAN

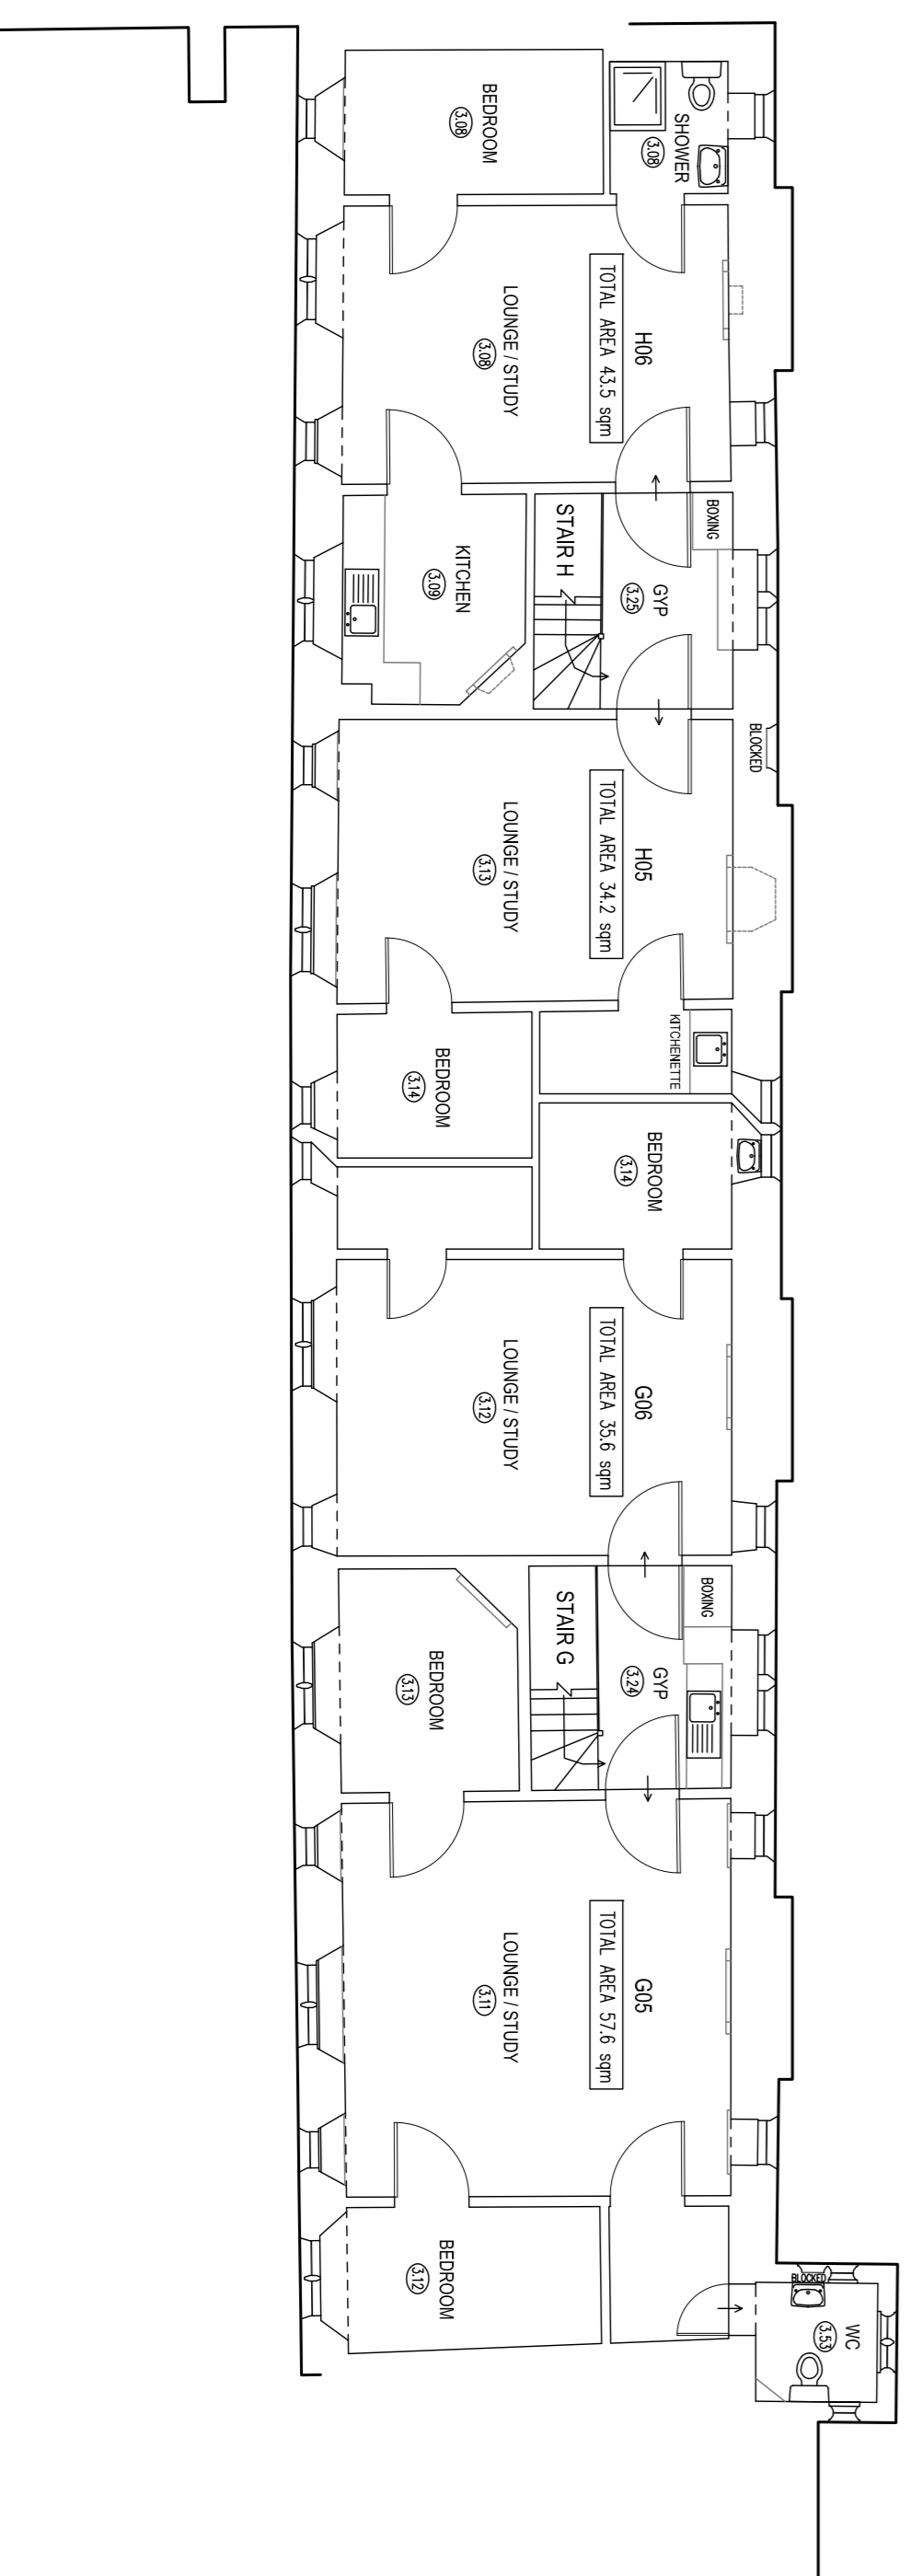

LEGEND

⬆	Telephone Socket	⬆	Key symbol for Direction
⬆	Electric Nxt Socket	⬆	Key symbol for Spacing Change
⬆	TV Aerial Socket	⬆	Key symbol for Up Direction
⬆	Fire Alarm Break Glass	⬆	Key symbol for Down Direction
⬆	Fire Alarm Sounder	⬆	Key symbol for Floor To Ceiling Heights
⬆	Fire Alarm Control Panel	⬆	Key symbol for Wall to Ceiling Heights
⬆	Fire Alarm Call Point	⬆	Key symbol for Key & Solid Detail
⬆	Smoke Detector	⬆	Change in Floor Construction etc
⬆	Illuminated Fire Exit Sign	⬆	"Hidden Detail" Under Stairs etc
⬆	Single Supply Socket	⬆	"Overhead" Beams, Roof Lights etc
⬆	Double Supply Socket	⬆	Finished floor level value
⬆	Single Gang Light Switch	⬆	Height of window sill and window head from floor
⬆	Double Gang Light Switch	⬆	SILL 1.00
⬆	Radiator	⬆	HEAD 2.00

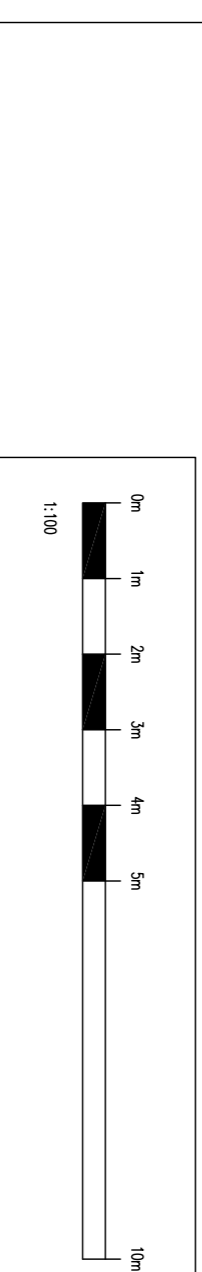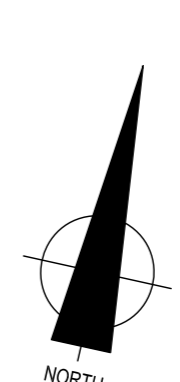

NOTES

SURVEY TIED INTO NATIONAL GRID OSN212 AND OSN402 DATUM FOR HEIGHT USING GPS EQUIPMENT UTILIZING THE TRIMBLE VRS NOW SYSTEM FOR REAL TIME KINEMATIC (RTK) CORRECTIONS NATIONAL GRID SCALE FACTOR HAS NOT BEEN APPLIED TO THE SURVEY UNLESS SPECIFIED

DRAINAGE AND SERVICE INFORMATION SHOWN ON THIS SURVEY HAS BEEN OBTAINED BY VISUAL INSPECTION ONLY, ALTHOUGH ALL POSSIBLE CARE HAS BEEN TAKEN TO ENSURE THAT DETAILS SHOWN ARE CORRECT, WE ARE UNABLE TO ACCEPT ANY RESPONSIBILITY FOR COSTS ARISING OUT OF ANY ERRORS OR OMISSIONS. COPYRIGHT: THIS DRAWING MAY NOT BE REPRODUCED IN ANY FORM WHATSOEVER WITHOUT THE CONSENT OF C J SURVEYS LTD.

C J SURVEYS LTD
 LAND | BUILDING | ENGINEERING
 PROFESSIONAL MEASURED SURVEYS

CLIENT: QUEENS COLLEGE

PROJECT: GROUND, FIRST & SECOND FLOOR LAYOUT PLANS
 WALNUT TREE COURT, QUEENS COLLEGE, CAMBRIDGE

DATE: APRIL 2019
 DRAWN: GSI/CJ
 SHEET SIZE SCALE: A1 1:100
 DRAWING NO.: 02619W/T1

Contact: Tel: 01638 591031, Mobile: 07945 775645, Email: me@csurveys.co.uk